

- GENERAL NOTES:-**
1. ALL DIMENSIONS ARE IN METERS AND (UNLESS NOTED OTHERWISE)
  2. DO NOT SCALE FROM THE DRAWINGS
  3. ANY DISCREPANCIES TO BE NOTED TO ARCHITECT IMMEDIATELY
  4. ALL DIMENSIONS TO BE CHECKED ON SITE
  5. ALL DRAWINGS SHOULD BE READ IN CONJUNCTION WITH OTHER RELEVANT DISCIPLINES AND CONTRACT DOCUMENTS



# Shop Drawing Interior Design Rural Communities Development Association



**Notes:**

This is a concept design details, shop drawings to be done by the contractors to meet the feel and look of the design perspectives, any discrepancy in the drawings the concept perspectives design should supersede and the contractor to highlight these before any execution to avoid any confusion and work execution miss matching the design concept.

Design concept :	Checked by :
Date :	Drawing No : 00

Client :
Project : REEF CHARITY
Space title : RECEPTION AREA
Drawing title:

- GENERAL NOTES:-**
1. ALL DIMENSIONS ARE IN METERS AND (UNLESS NOTED OTHERWISE)
  2. DO NOT SCALE FROM THE DRAWINGS
  3. ANY DISCREPANCIES TO BE NOTED TO ARCHITECT IMMEDIATELY
  4. ALL DIMENSIONS TO BE CHECKED ON SITE
  5. ALL DRAWINGS SHOULD BE READ IN CONJUNCTION WITH OTHER RELEVANT DISCIPLINES AND CONTRACT DOCUMENTS

# RECEPTION AREA


Client :  
 Project :  
**REEF CHARITY**  
 Space title :  
**RECEPTION AREA**  
 Drawing title:

Design concept :  
 Checked by :  
 Date :  
 Drawing No : 00

**Notes:**  
 This is a concept design details, shop drawings to be done by the contractors to meet the feel and look of the design perspectives, any discrepancy in the drawings the concept perspectives design should supersede and the contractor to highlight these before any execution to avoid any confusion and work execution miss matching the design concept.

**GENERAL NOTES:-**

- 1. ALL DIMENSIONS ARE IN METERS AND (UNLESS NOTED OTHERWISE)
- 2. DO NOT SCALE FROM THE DRAWINGS
- 3. ANY DISCREPANCIES TO BE NOTED TO ARCHITECT IMMEDIATELY
- 4. ALL DIMENSIONS TO BE CHECKED ON SITE
- 5. ALL DRAWINGS SHOULD BE READ IN CONJUNCTION WITH OTHER RELEVANT DISCIPLINES AND CONTRACT DOCUMENTS

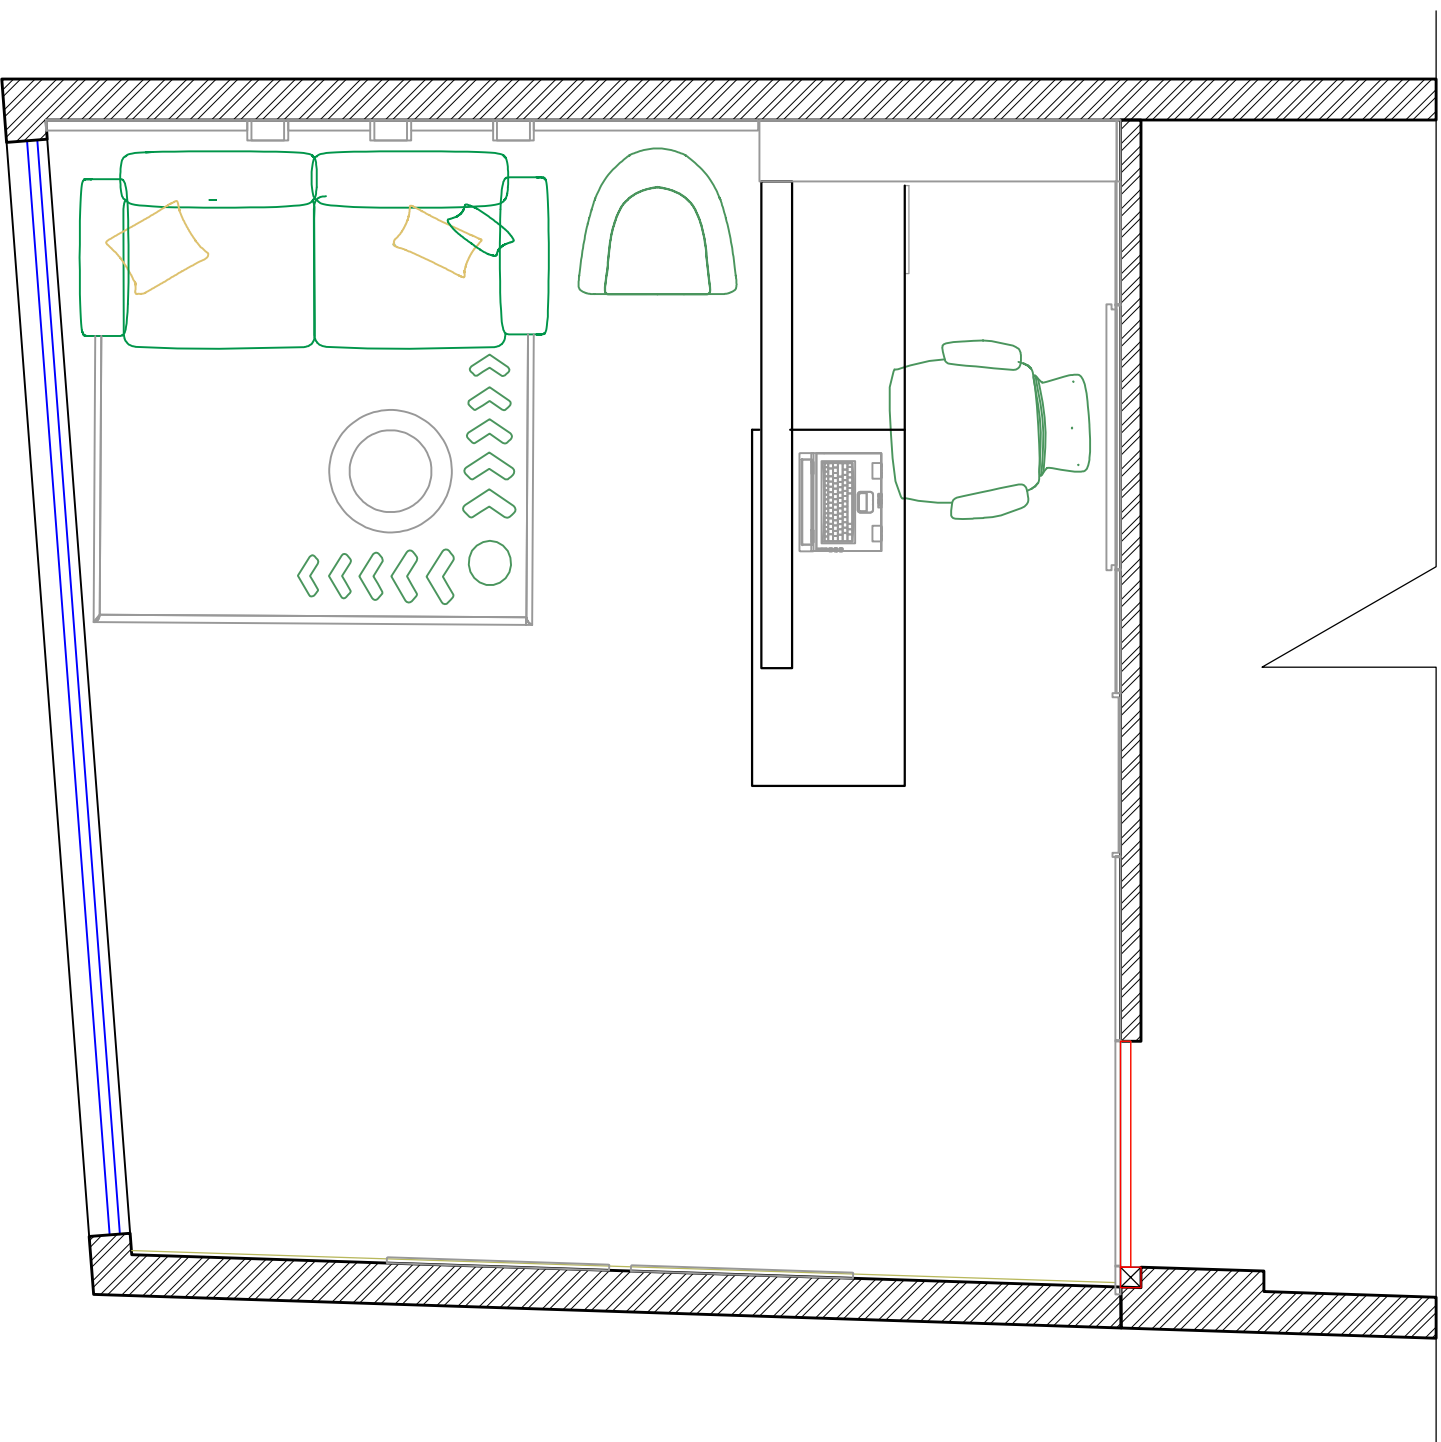

**GROUND FLOOR  
FURNITURE PLAN**


**1**  
SCALE 1:50

**Notes:**

This is a concept design details, shop drawings to be done by the contractors to meet the feel and look of the design perspectives, any discrepancy in the drawings the concept perspectives design should supersede and the contractor to highlight these before any execution to avoid any confusion and work execution miss matching the design concept.

Client :	
Project :	Residential Villa
Space title :	Girls Bedroom
Drawing title:	
Design concept :	Checked by :
Date :	Drawing No : 00

- GENERAL NOTES:-**
1. ALL DIMENSIONS ARE IN METERS AND (UNLESS NOTED OTHERWISE)
  2. DO NOT SCALE FROM THE DRAWINGS
  3. ANY DISCREPANCIES TO BE NOTED TO ARCHITECT IMMEDIATELY
  4. ALL DIMENSIONS TO BE CHECKED ON SITE
  5. ALL DRAWINGS SHOULD BE READ IN CONJUNCTION WITH OTHER RELEVANT DISCIPLINES AND CONTRACT DOCUMENTS

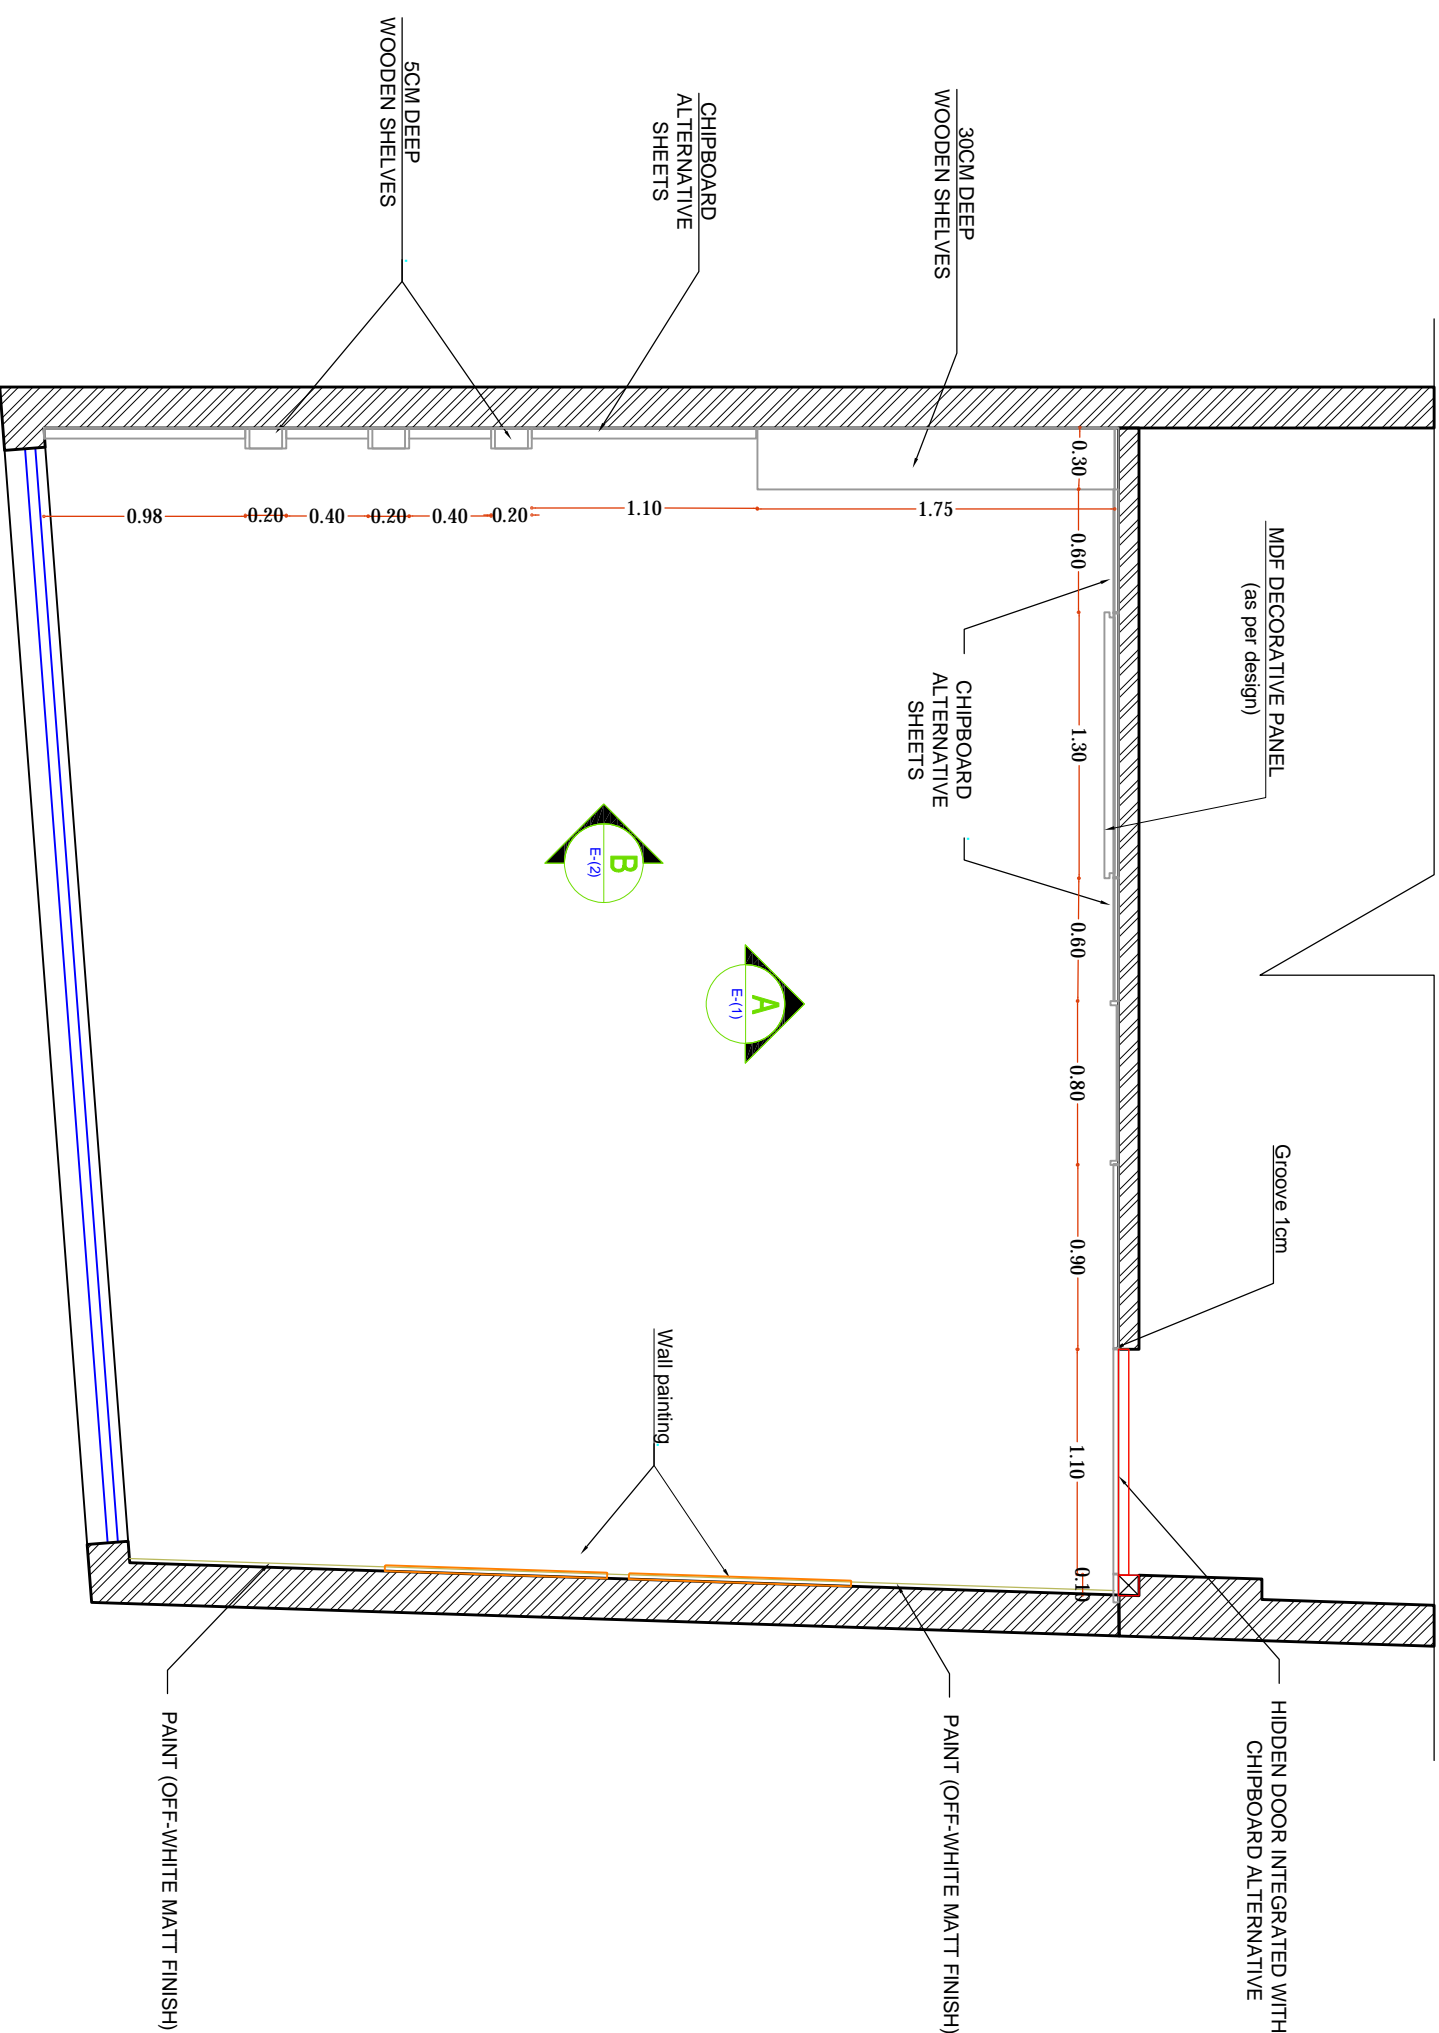


GROUND FLOOR  
**2 DECORATION PLAN**  
 SCALE 1:50

**Notes:**  
 This is a concept design details, shop drawings to be done by the contractors to meet the feel and look of the design perspectives, any discrepancy in the drawings the concept perspectives design should supersede and the contractor to highlight these before any execution to avoid any confusion and work execution miss matching the design concept.

Client :	
Project :	REEF CHARITY
Space title :	RECEPTION AREA
Drawing title:	
Design concept :	Checked by :
Date :	Drawing No : 00

- GENERAL NOTES:-**
1. ALL DIMENSIONS ARE IN METERS AND (UNLESS NOTED OTHERWISE)
  2. DO NOT SCALE FROM THE DRAWINGS
  3. ANY DISCREPANCIES TO BE NOTED TO ARCHITECT IMMEDIATELY
  4. ALL DIMENSIONS TO BE CHECKED ON SITE
  5. ALL DRAWINGS SHOULD BE READ IN CONJUNCTION WITH OTHER RELEVANT DISCIPLINES AND CONTRACT DOCUMENTS

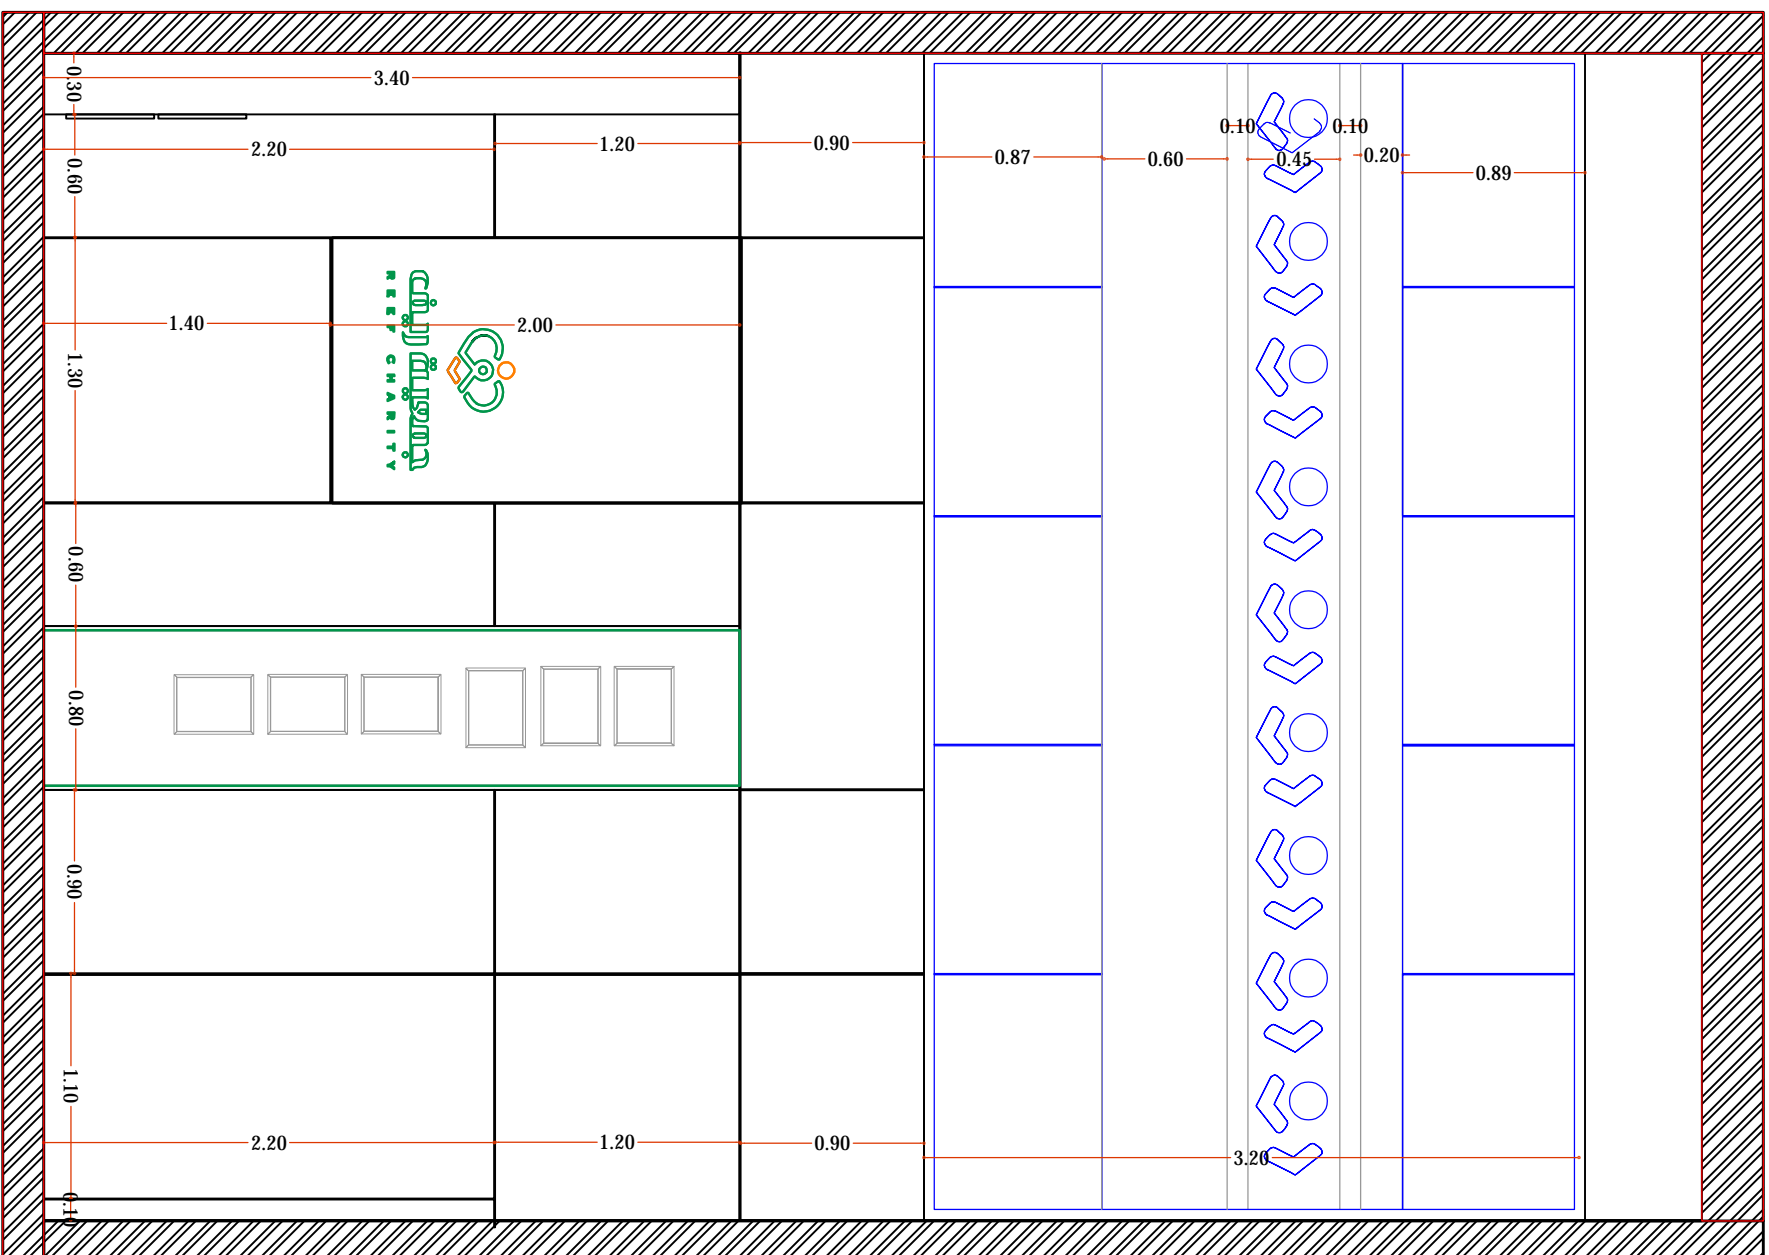


**GROUND FLOOR**  
**ELEVATION A (1)**  
**SCALE 1:50**

**Notes:**  
 This is a concept design details, shop drawings to be done by the contractors to meet the feel and look of the design perspectives, any discrepancy in the drawings the concept perspectives design should supersede and the contractor to highlight these before any execution to avoid any confusion and work execution miss matching the design concept.

Client :	
Project :	
Space title : <b>REEF CHARITY</b>	
Drawing title : <b>RECEPTION AREA</b>	
Design concept :	Checked by :
Date :	Drawing No : 00

**GENERAL NOTES:-**

1. ALL DIMENSIONS ARE IN METERS AND (UNLESS NOTED OTHERWISE)
2. DO NOT SCALE FROM THE DRAWINGS
3. ANY DISCREPANCIES TO BE NOTED TO ARCHITECT IMMEDIATELY
4. ALL DIMENSIONS TO BE CHECKED ON SITE
5. ALL DRAWINGS SHOULD BE READ IN CONJUNCTION WITH OTHER RELEVANT DISCIPLINES AND CONTRACT DOCUMENTS



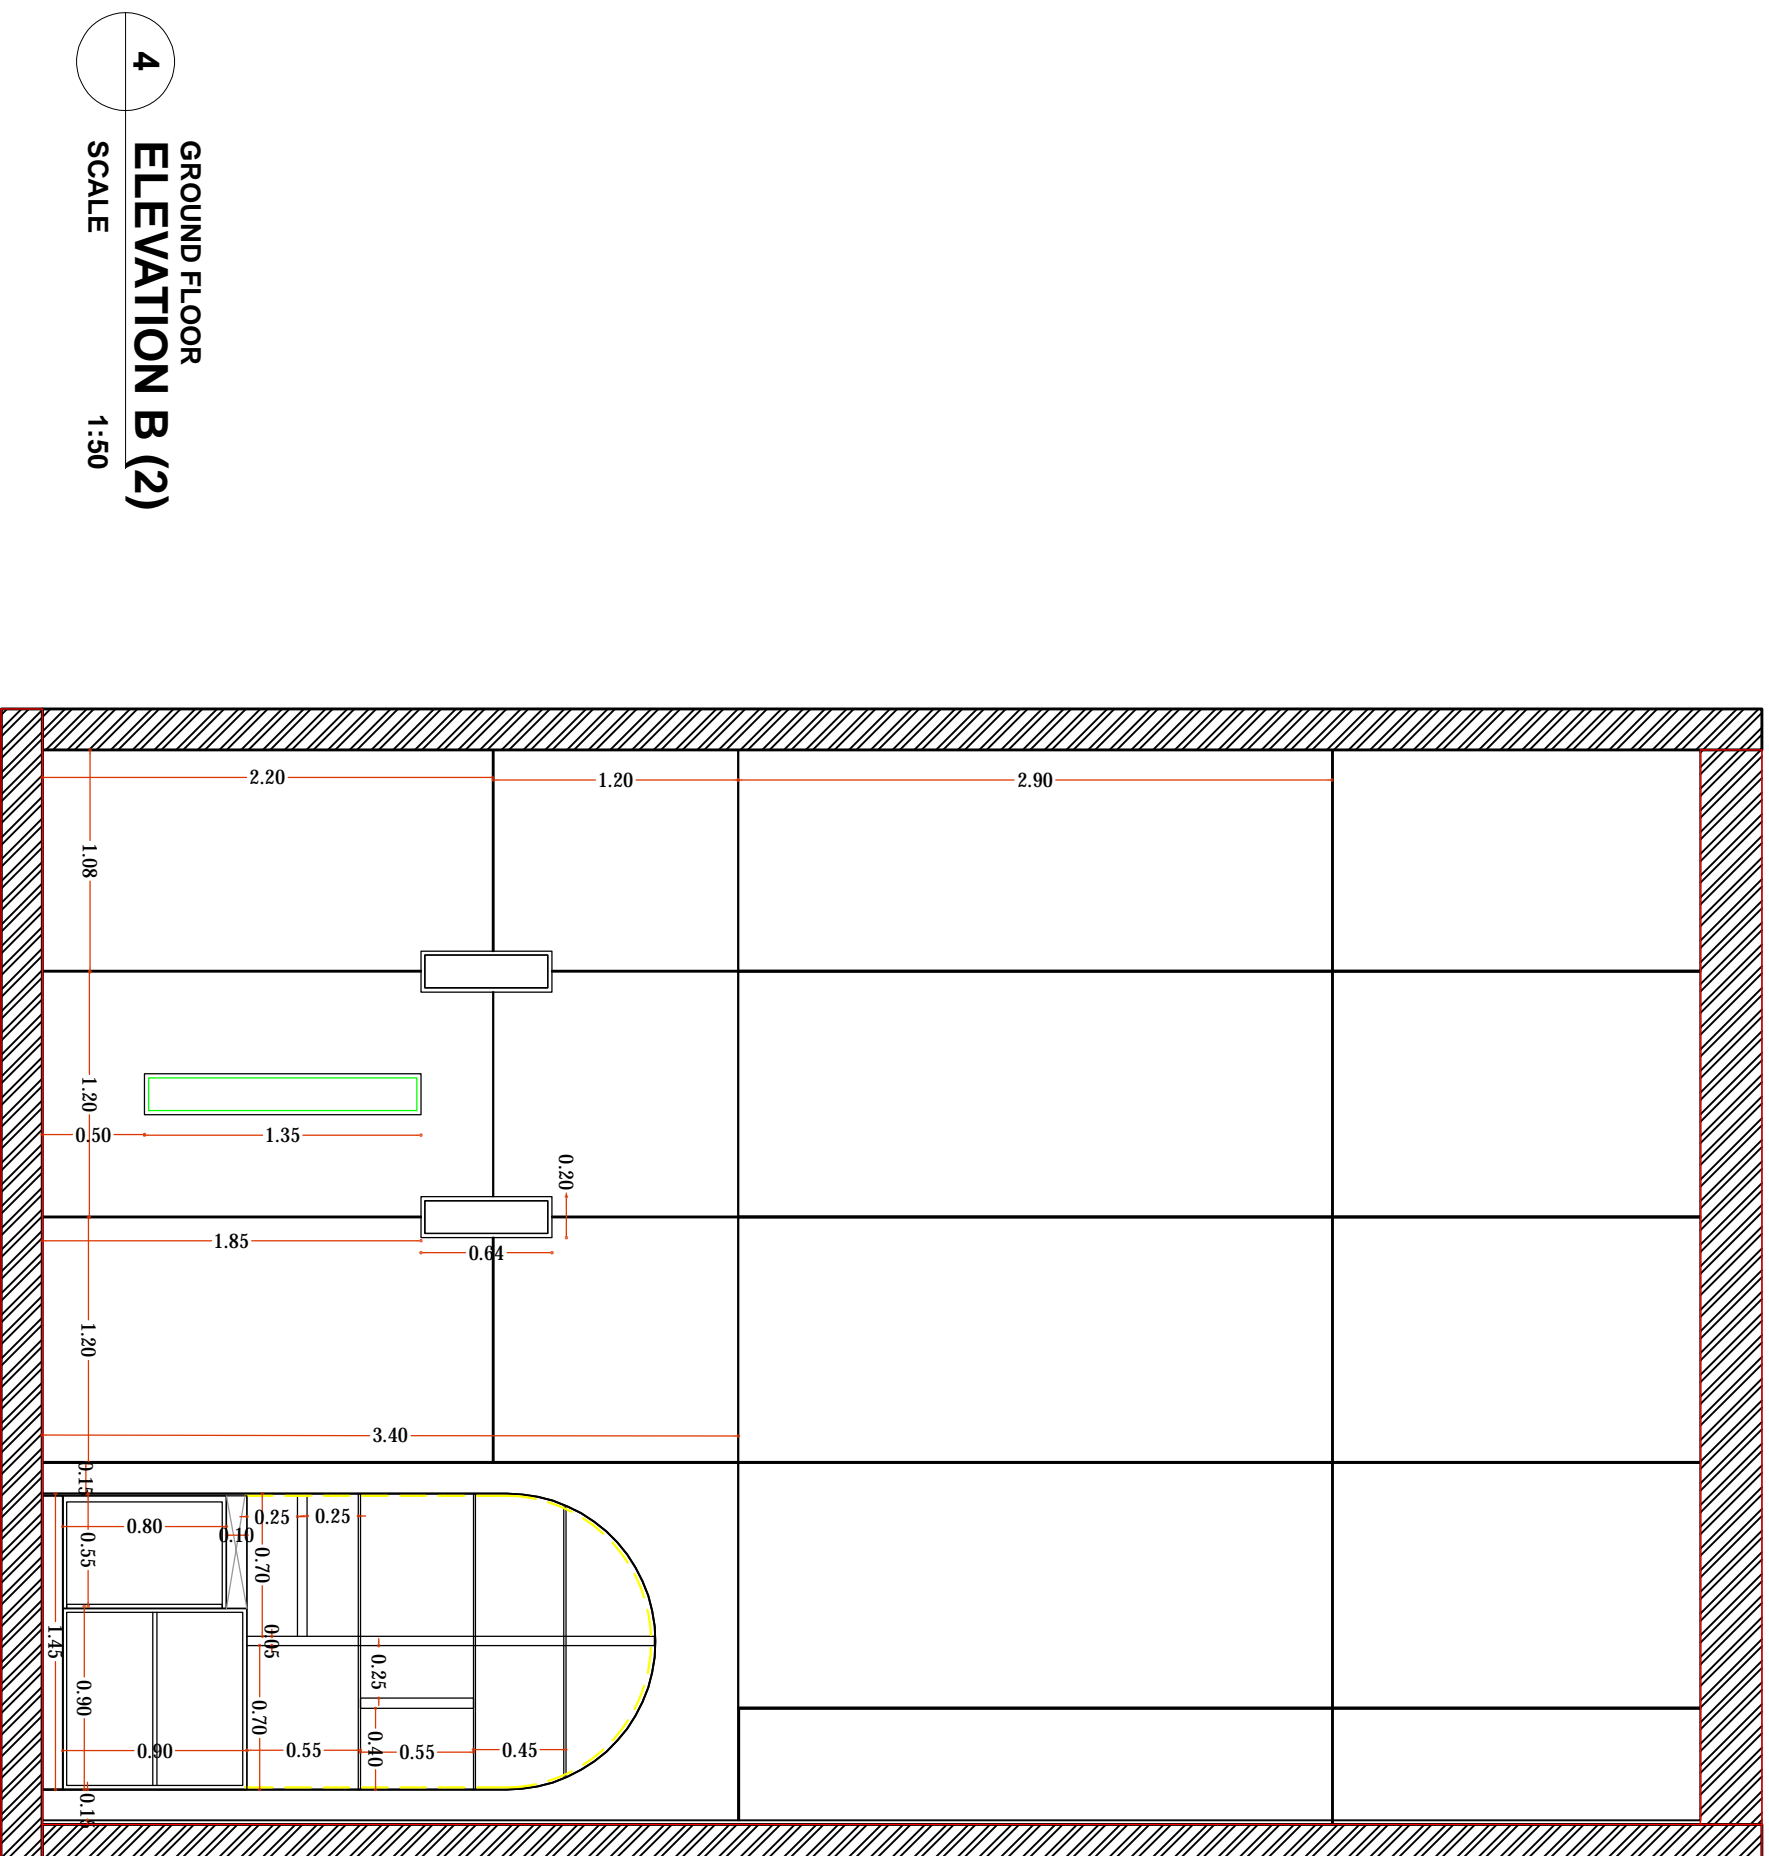


**4** GROUND FLOOR  
**ELEVATION B (2)**  
SCALE 1:50

**Notes:**

This is a concept design details, shop drawings to be done by the contractors to meet the feel and look of the design perspectives, any discrepancy in the drawings the concept perspectives design should supersede and the contractor to highlight these before any execution to avoid any confusion and work execution miss matching the design concept.

<p>Client : _____</p>	
<p>Project : <b>REEF CHARITY</b></p>	
<p>Space title : <b>RECEPTION AREA</b></p>	
<p>Drawing title : _____</p>	
<p>Design concept :</p>	<p>Checked by :</p>
<p>Date :</p>	<p>Drawing No : 00</p>

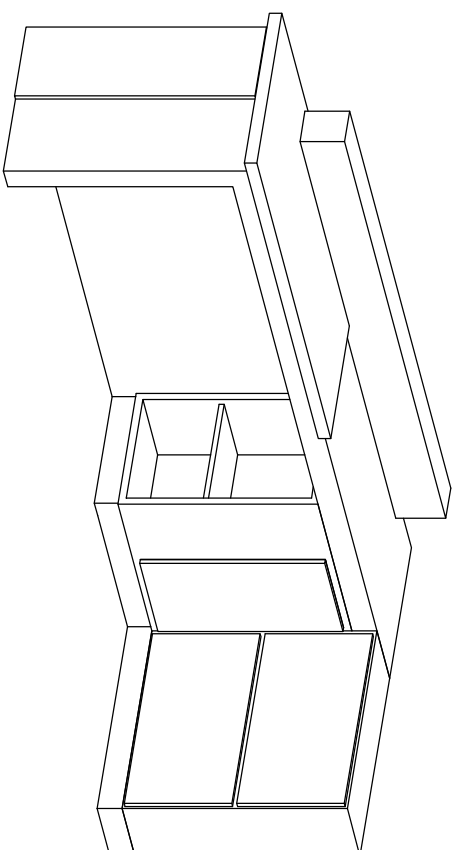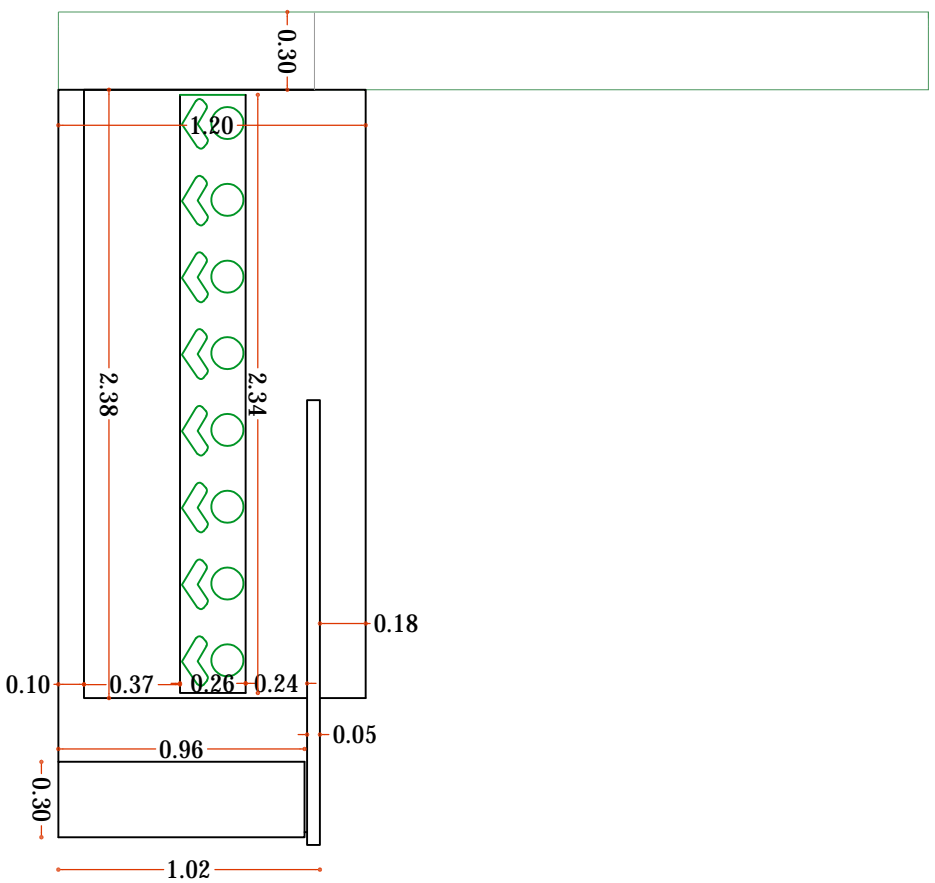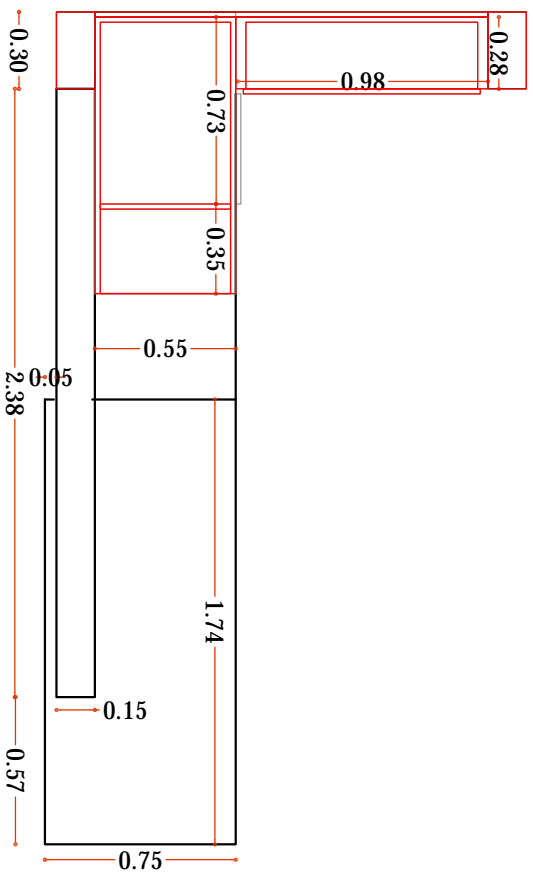

GROUND FLOOR  
**5 RECEPTION**

**Notes:**

This is a concept design details, shop drawings to be done by the contractors to meet the feel and look of the design perspectives, any discrepancy in the drawings the concept perspectives design should supersede and the contractor to highlight these before any execution to avoid any confusion and work execution miss matching the design concept.

**GENERAL NOTES:-**

1. ALL DIMENSIONS ARE IN METERS AND (UNLESS NOTED OTHERWISE)
2. DO NOT SCALE FROM THE DRAWINGS
3. ANY DISCREPANCIES TO BE NOTED TO ARCHITECT IMMEDIATELY
4. ALL DIMENSIONS TO BE CHECKED ON SITE
5. ALL DRAWINGS SHOULD BE READ IN CONJUNCTION WITH OTHER RELEVANT DISCIPLINES AND CONTRACT DOCUMENTS

Client :

Project :

REEF CHARITY


Space title :

RECEPTION AREA

Drawing title :

Design concept : Checked by :

Date : Drawing No : 00

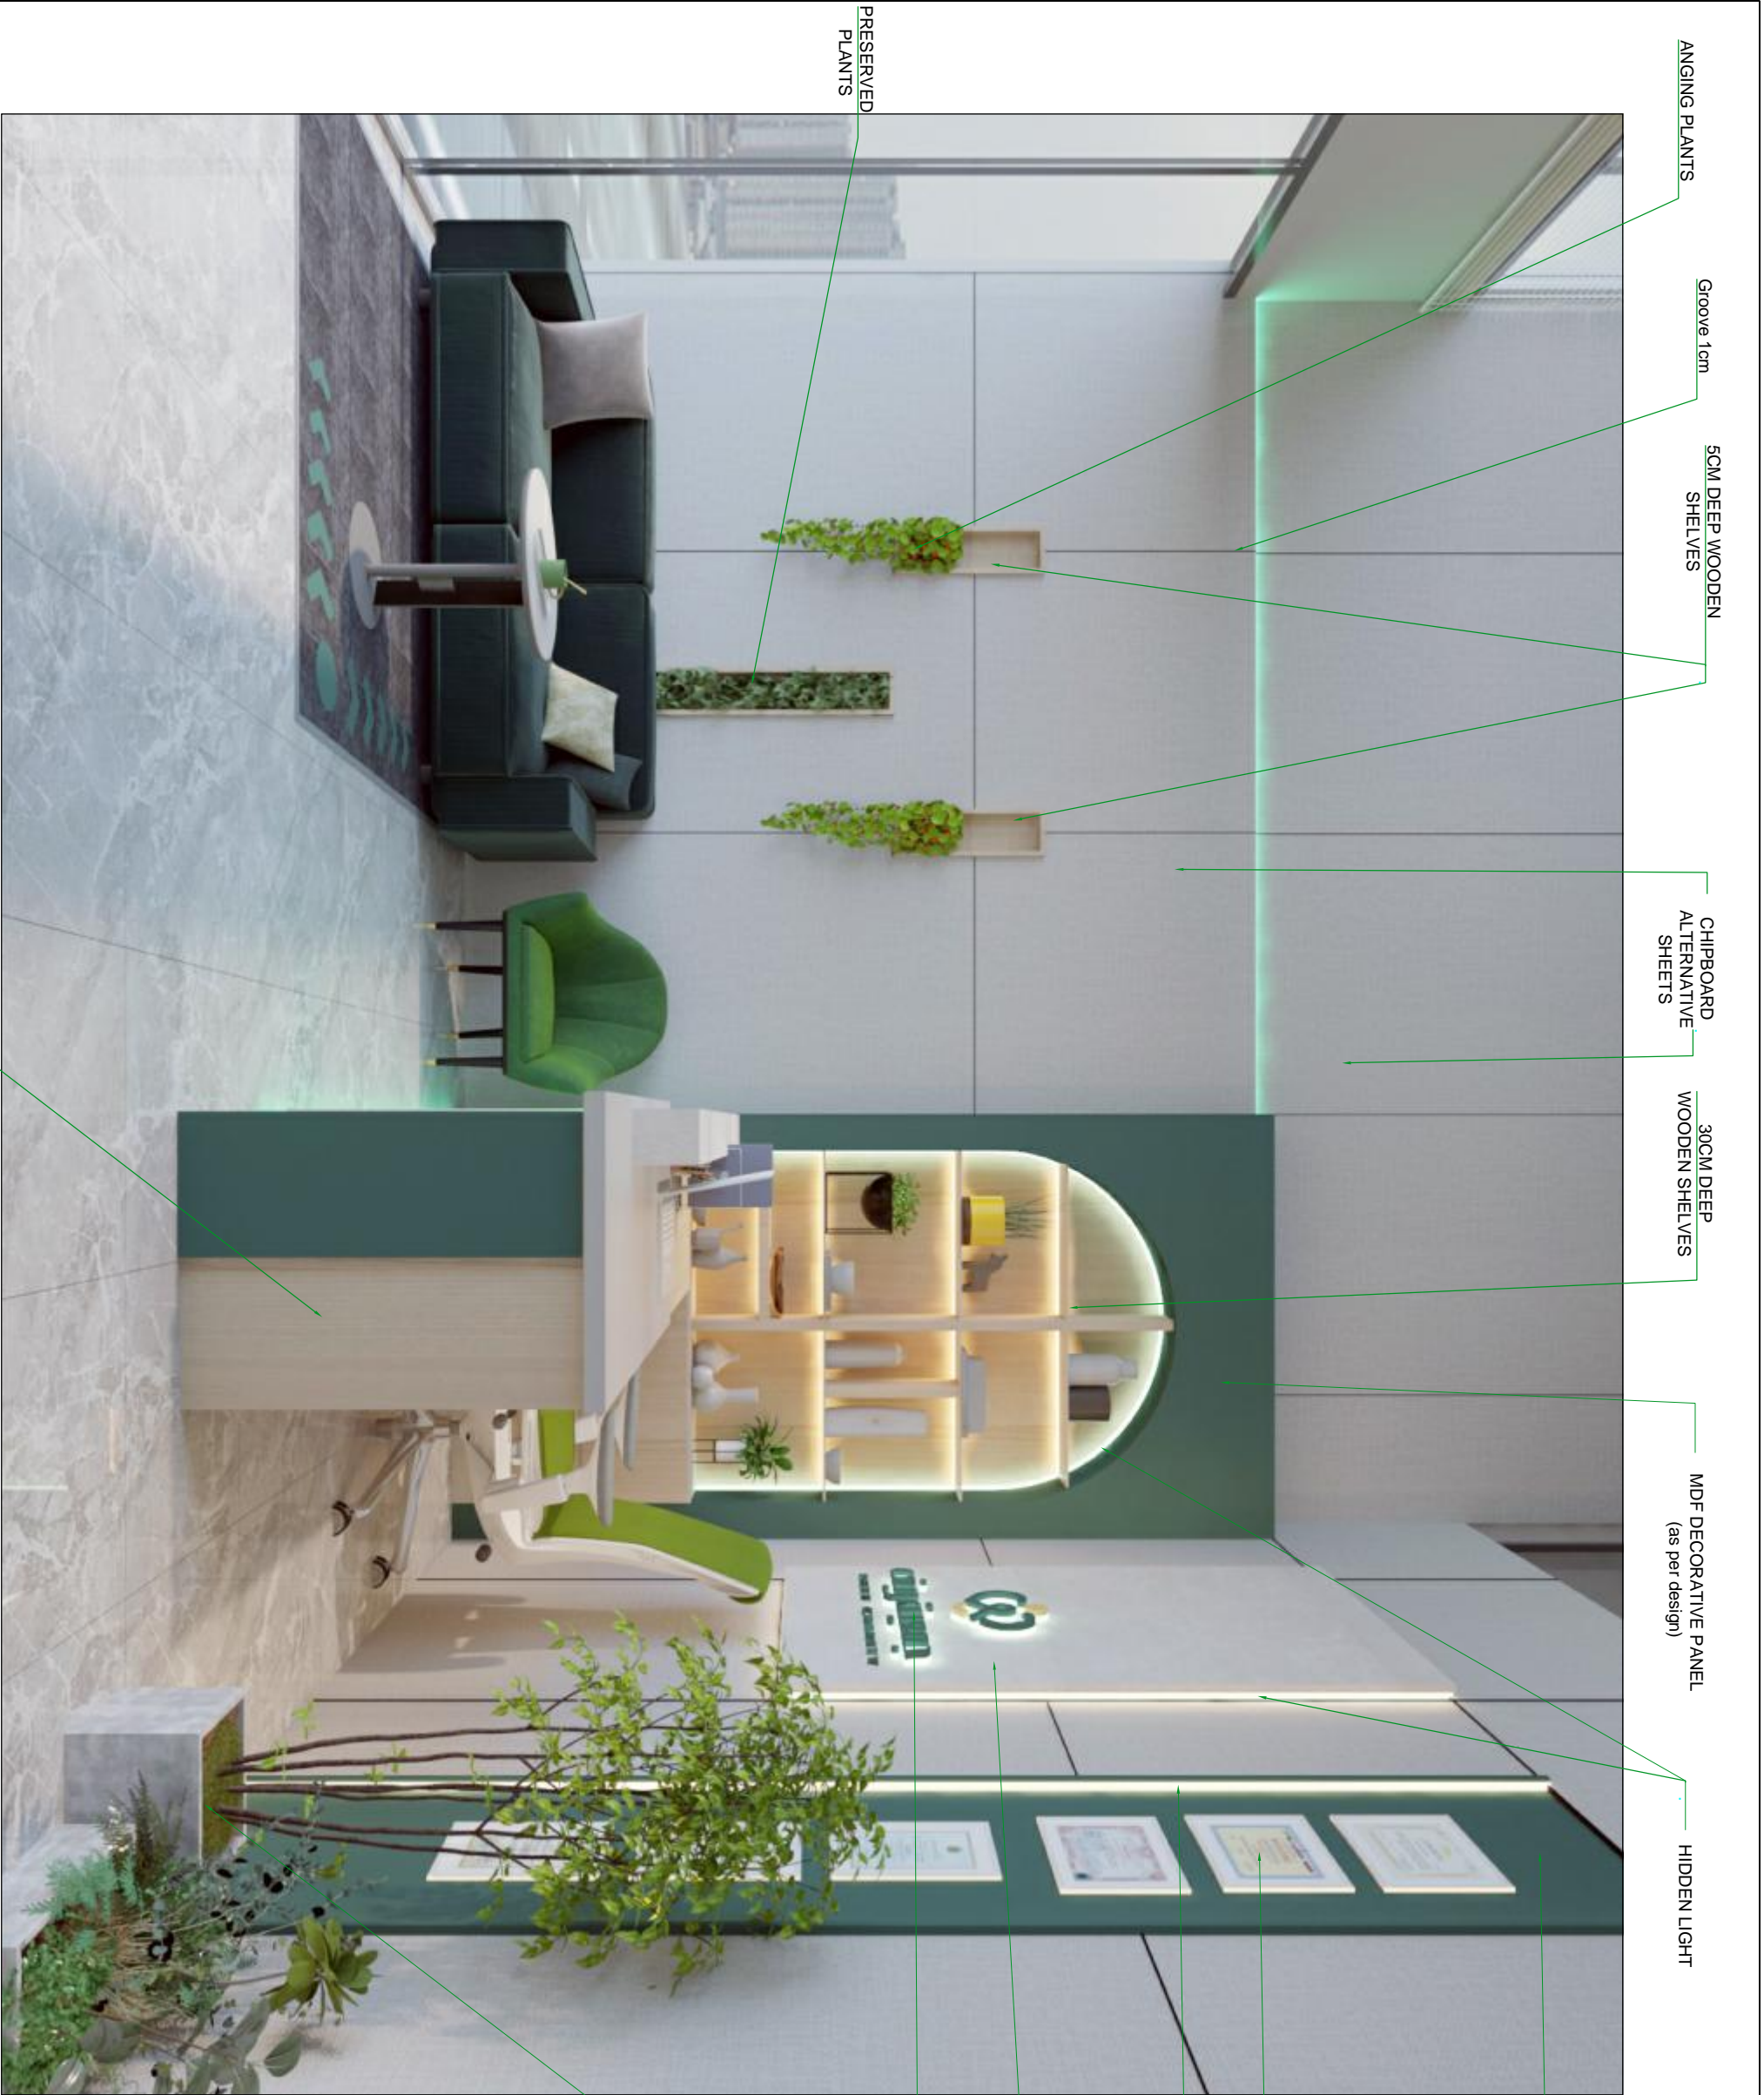

HANGING PLANTS

Groove 1cm

5CM DEEP WOODEN SHELVES

CHIPBOARD ALTERNATIVE SHEETS

30CM DEEP WOODEN SHELVES

MDF DECORATIVE PANEL (as per design)

HIDDEN LIGHT

GREEN FEATURE WALL

Certificate Frames

LED Strip

MDF DECORATIVE PANEL (as per design)

3D ACRYLIC LOGO, 10mm thickness,

PRESERVED PLANTS

Floor Planters

RECEPTION

Client : _____	
Project : <b>REEF CHARITY</b>	
Space title : <b>RECEPTION AREA</b>	
Drawing title : _____	
Design concept :	Checked by :
Date :	Drawing No : 00



CHIPBOARD  
ALTERNATIVE  
SHEETS

MDF DECORATIVE PANEL  
(as per design)

3D ACRYLIC LOGO,  
10mm thickness,

SCM DEEP WOODEN  
SHELVES

HANGING PLANTS

CHIPBOARD  
ALTERNATIVE  
SHEETS

HIDDEN LIGHT

GREEN FEATURE WALL

FROSTED GLASS FILM

MEZZANINE GLASS PARTITION

PAINT (OFF-WHITE MATT FINISH)

Groove 1cm

Wall painting

HIDDEN DOOR INTEGRATED WITH  
CHIPBOARD ALTERNATIVE

Client :

Project :

REEF CHARITY

Space title :

RECEPTION AREA

Drawing title :

Design concept :


Checked by :

Date :

Drawing No : 00

**GENERAL NOTES:-**

1. ALL DIMENSIONS ARE IN METERS AND (UNLESS NOTED OTHERWISE)
2. DO NOT SCALE FROM THE DRAWINGS
3. ANY DISCREPANCIES TO BE NOTED TO ARCHITECT IMMEDIATELY
4. ALL DIMENSIONS TO BE CHECKED ON SITE
5. ALL DRAWINGS SHOULD BE READ IN CONJUNCTION WITH OTHER RELEVANT DISCIPLINES AND CONTRACT DOCUMENTS

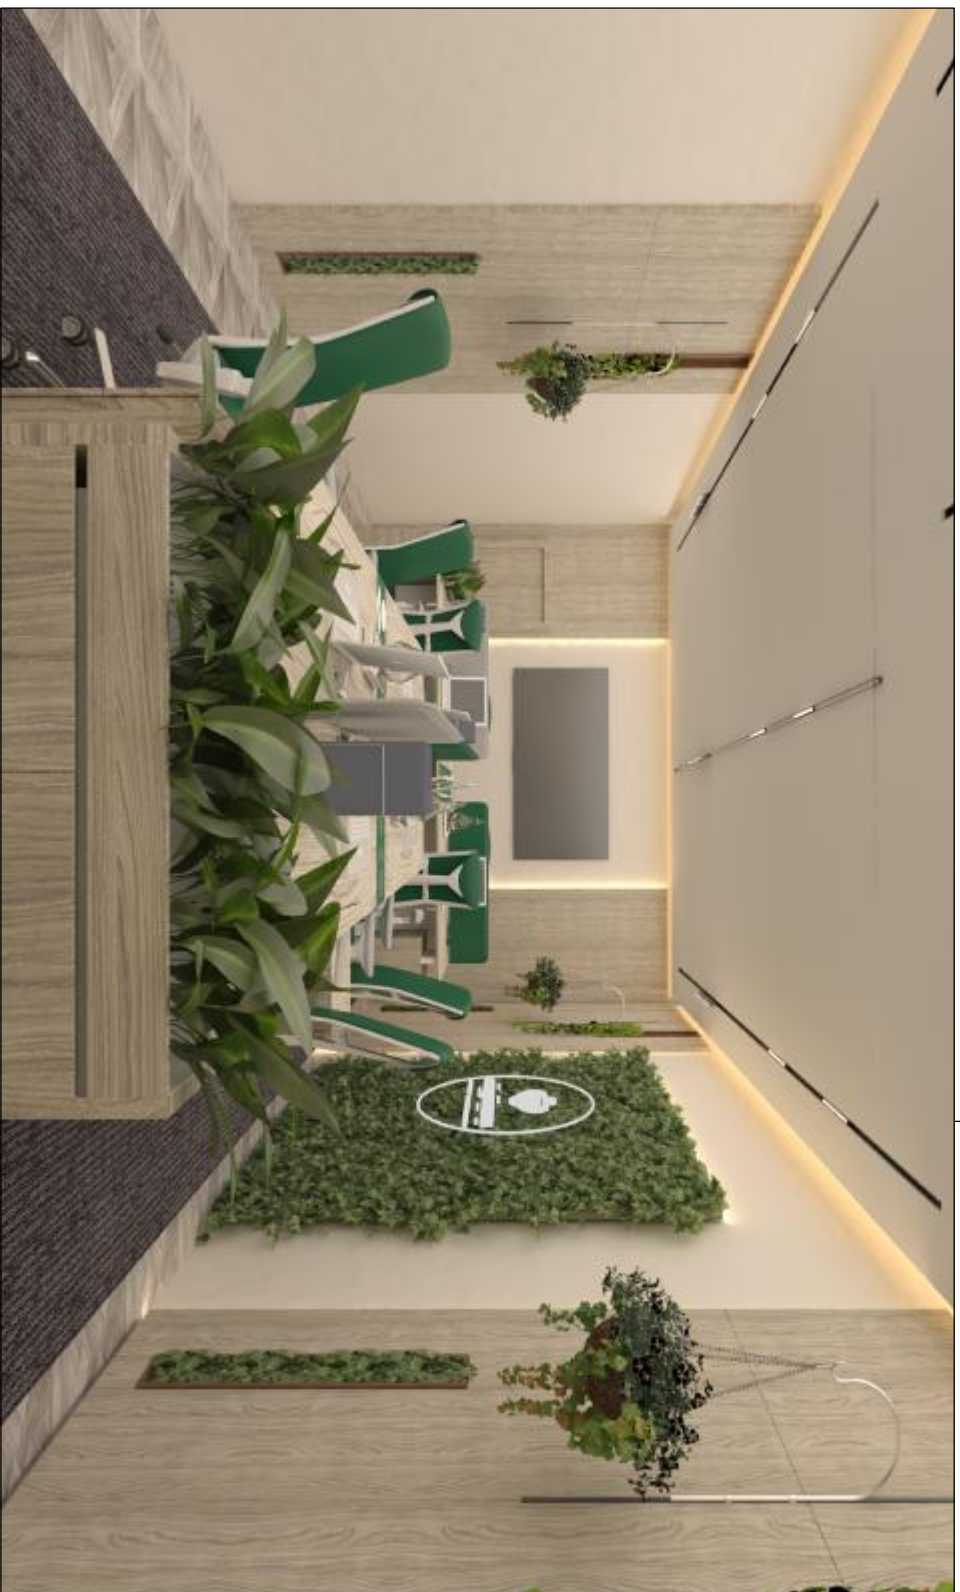

Client :

Project :

**Residential**

Space title :

**Administrative offices**

Drawing title:

Design concept :

Checked by :


**Notes:**

This is a concept design details, shop drawings to be done by the contractors to meet the feel and look of the design perspectives, any discrepancy in the drawings the concept perspectives design should supersede and the contractor to highlight these before any execution to avoid any confusion and work execution miss matching the design concept.

Date :

Drawing No : 00

- GENERAL NOTES:-**
1. ALL DIMENSIONS ARE IN METERS AND (UNLESS NOTED OTHERWISE)
  2. DO NOT SCALE FROM THE DRAWINGS
  3. ANY DISCREPANCIES TO BE NOTED TO ARCHITECT IMMEDIATELY
  4. ALL DIMENSIONS TO BE CHECKED ON SITE
  5. ALL DRAWINGS SHOULD BE READ IN CONJUNCTION WITH OTHER RELEVANT DISCIPLINES AND CONTRACT DOCUMENTS

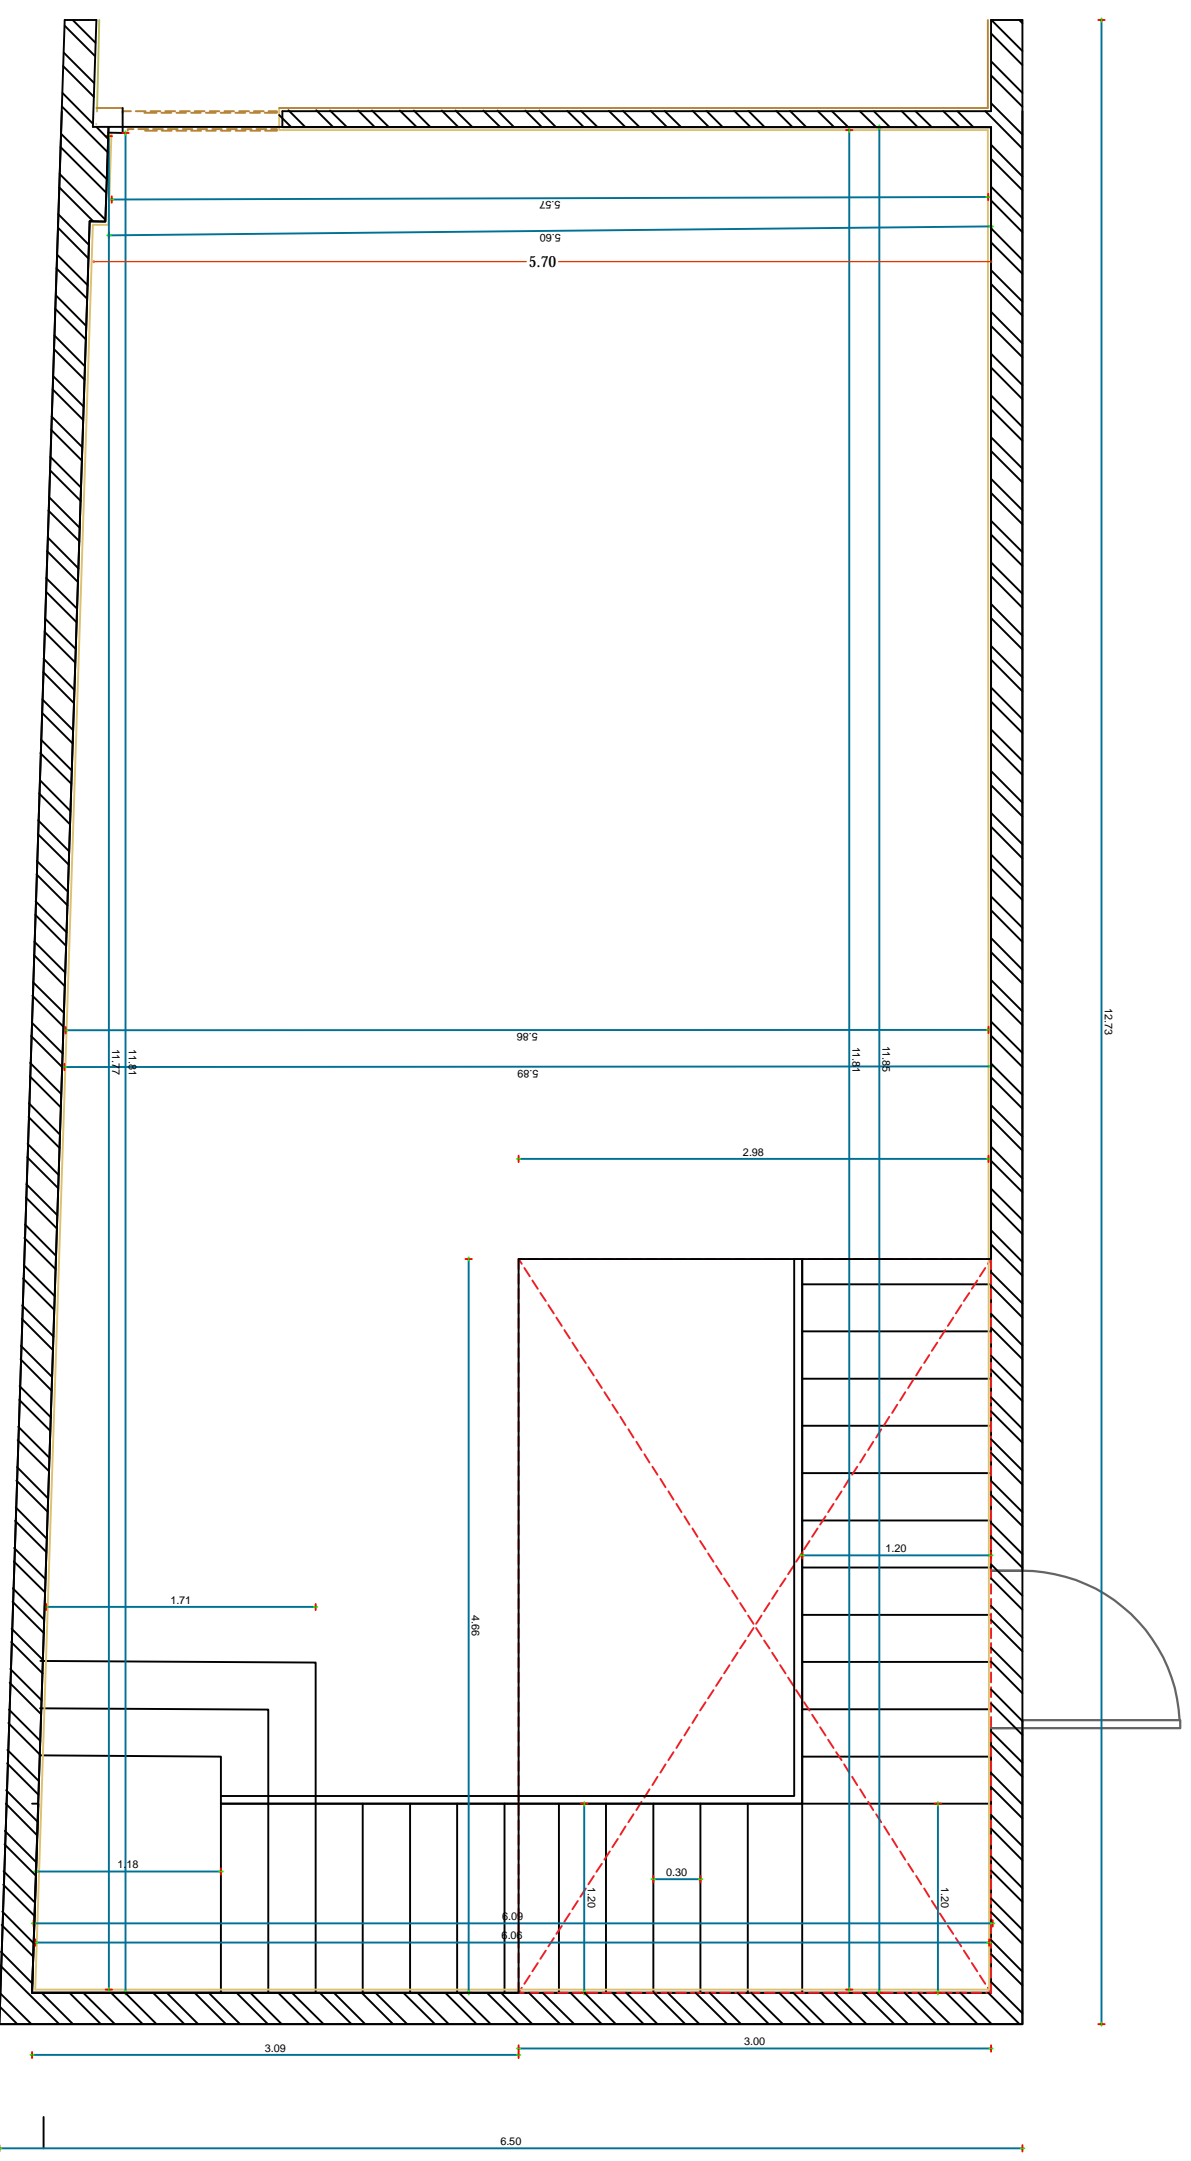


1 GROUND FLOOR  
**DIMENSION PLAN**  
 SCALE 1:50

**Notes:**  
 This is a concept design details, shop drawings to be done by the contractors to meet the feel and look of the design perspectives, any discrepancy in the drawings the concept perspectives design should supersede and the contractor to highlight these before any execution to avoid any confusion and work execution miss matching the design concept.

Client :	
Project :	
Residential	
Space title : <b>Administrative offices</b>	
Drawing title :	
Design concept :	Checked by :
Date :	Drawing No : 00

- GENERAL NOTES:-**
1. ALL DIMENSIONS ARE IN METERS AND (UNLESS NOTED OTHERWISE)
  2. DO NOT SCALE FROM THE DRAWINGS
  3. ANY DISCREPANCIES TO BE NOTED TO ARCHITECT IMMEDIATELY
  4. ALL DIMENSIONS TO BE CHECKED ON SITE
  5. ALL DRAWINGS SHOULD BE READ IN CONJUNCTION WITH OTHER RELEVANT DISCIPLINES AND CONTRACT DOCUMENTS

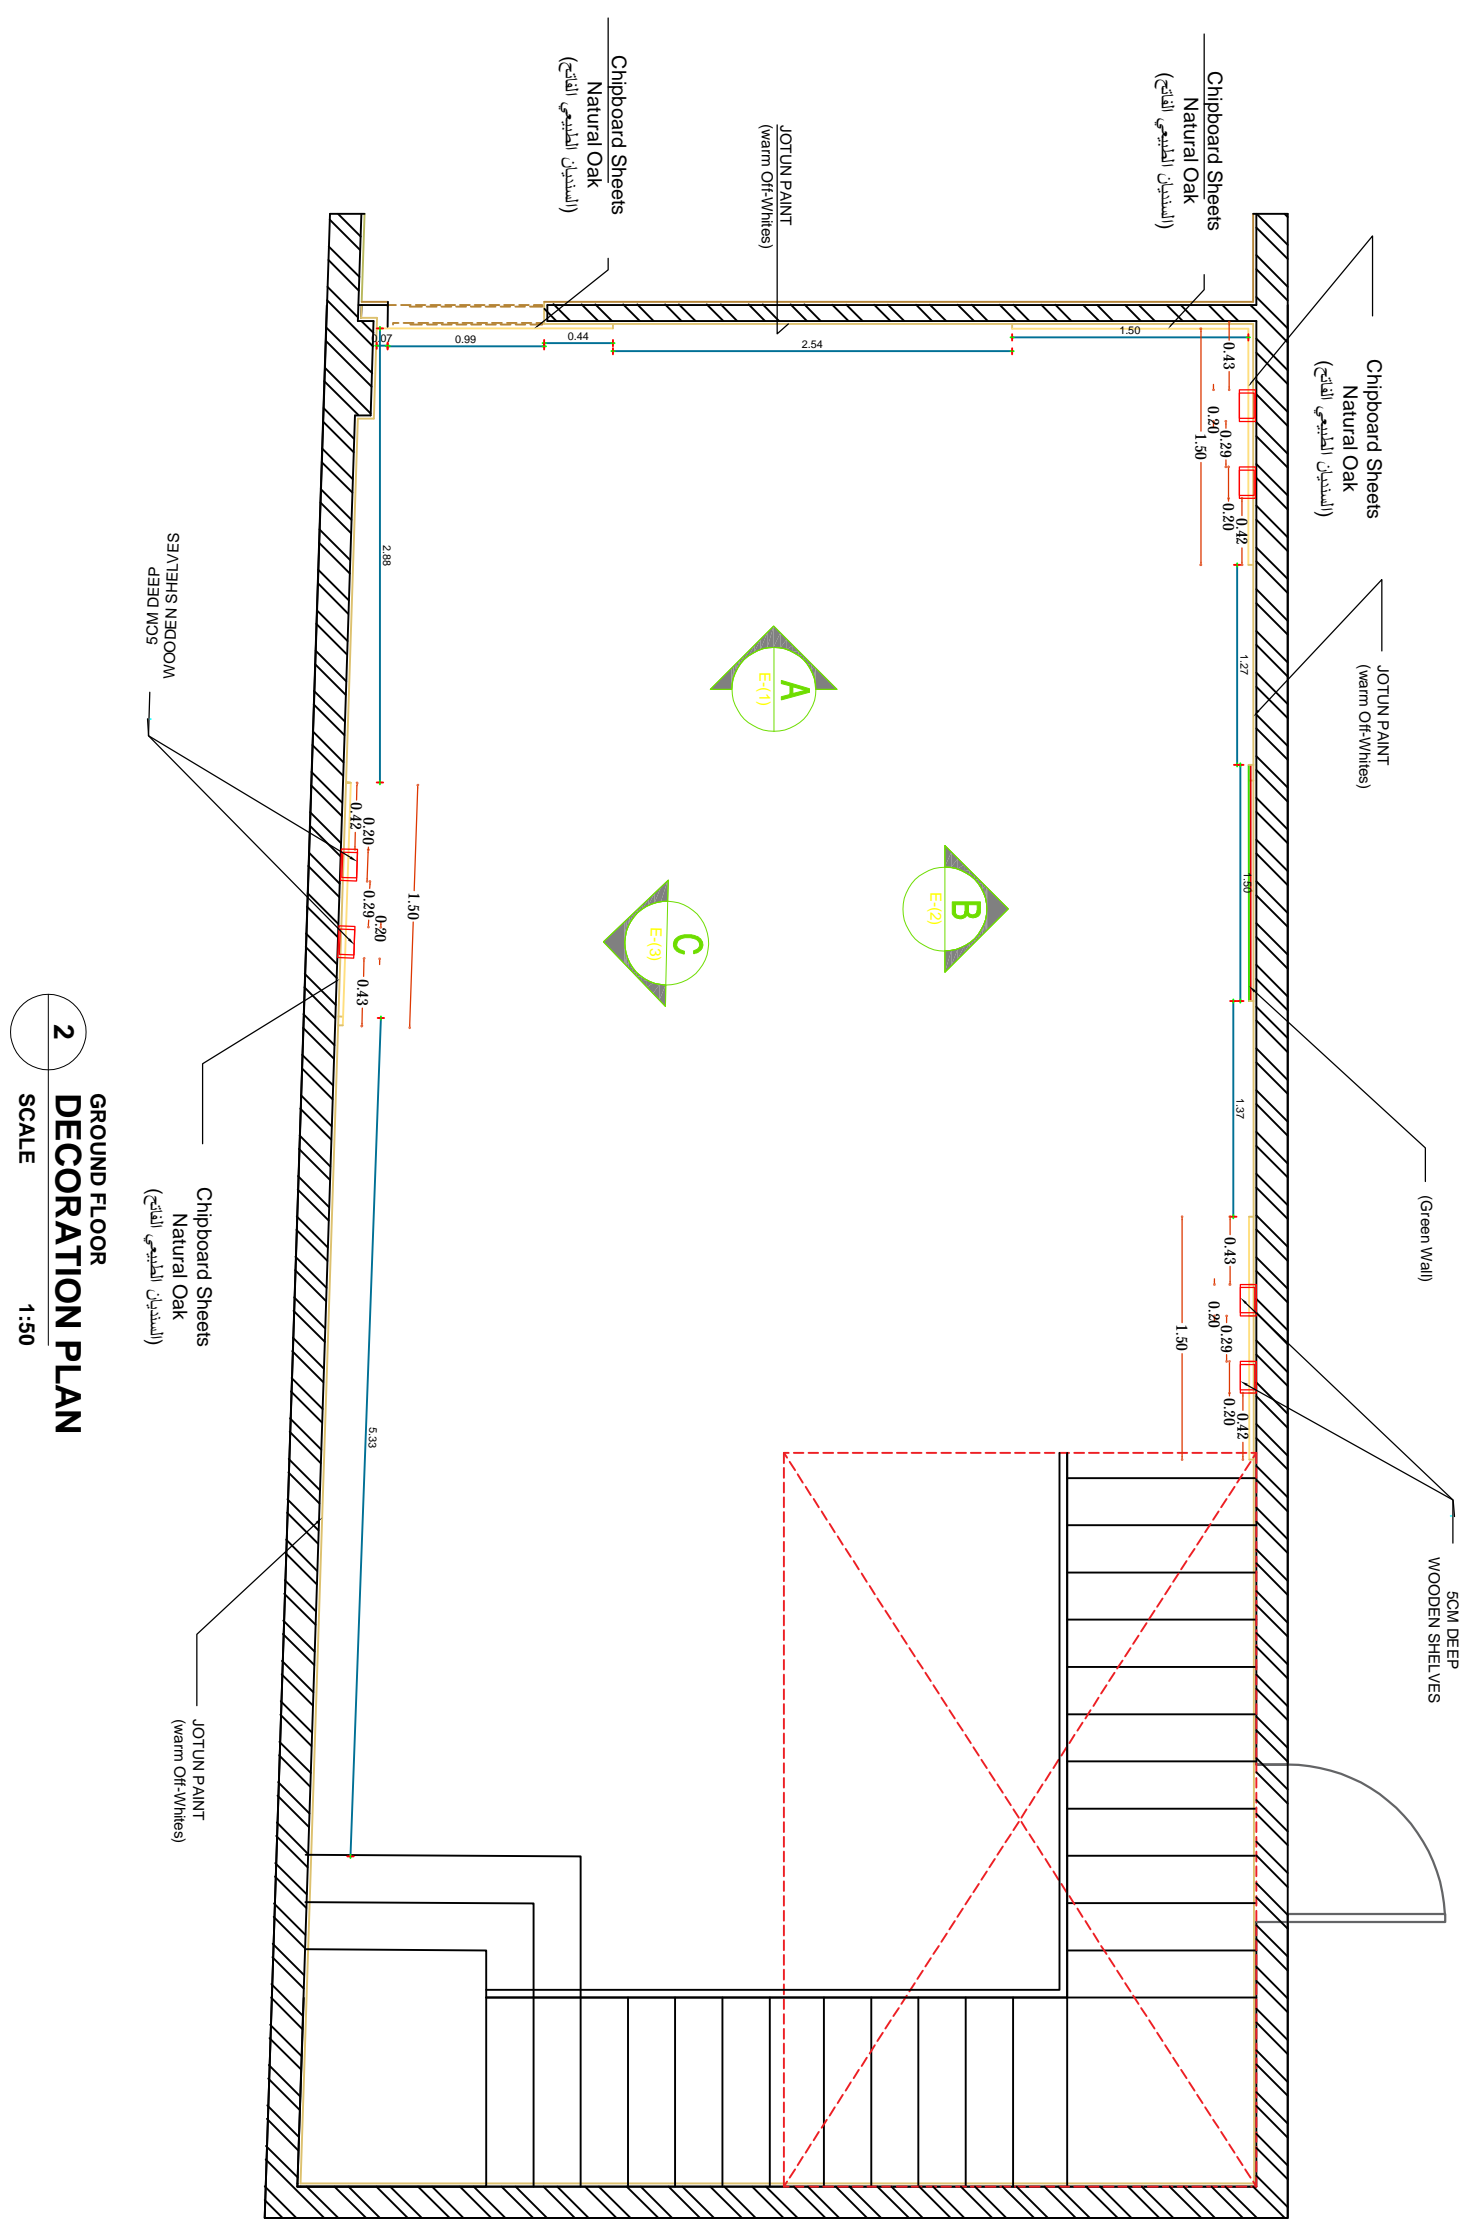


**GROUND FLOOR  
DECORATION PLAN**  
SCALE 1:50

**Notes:**  
This is a concept design details, shop drawings to be done by the contractors to meet the feel and look of the design perspectives, any discrepancy in the drawings the concept perspectives design should supersede and the contractor to highlight these before any execution to avoid any confusion and work execution miss matching the design concept.

Client :	
Project :	Residential
Space title :	Administrative offices
Drawing title:	
Design concept :	Checked by :
Date :	Drawing No : 00

- GENERAL NOTES:-**
1. ALL DIMENSIONS ARE IN METERS AND (UNLESS NOTED OTHERWISE)
  2. DO NOT SCALE FROM THE DRAWINGS
  3. ANY DISCREPANCIES TO BE NOTED TO ARCHITECT IMMEDIATELY
  4. ALL DIMENSIONS TO BE CHECKED ON SITE
  5. ALL DRAWINGS SHOULD BE READ IN CONJUNCTION WITH OTHER RELEVANT DISCIPLINES AND CONTRACT DOCUMENTS

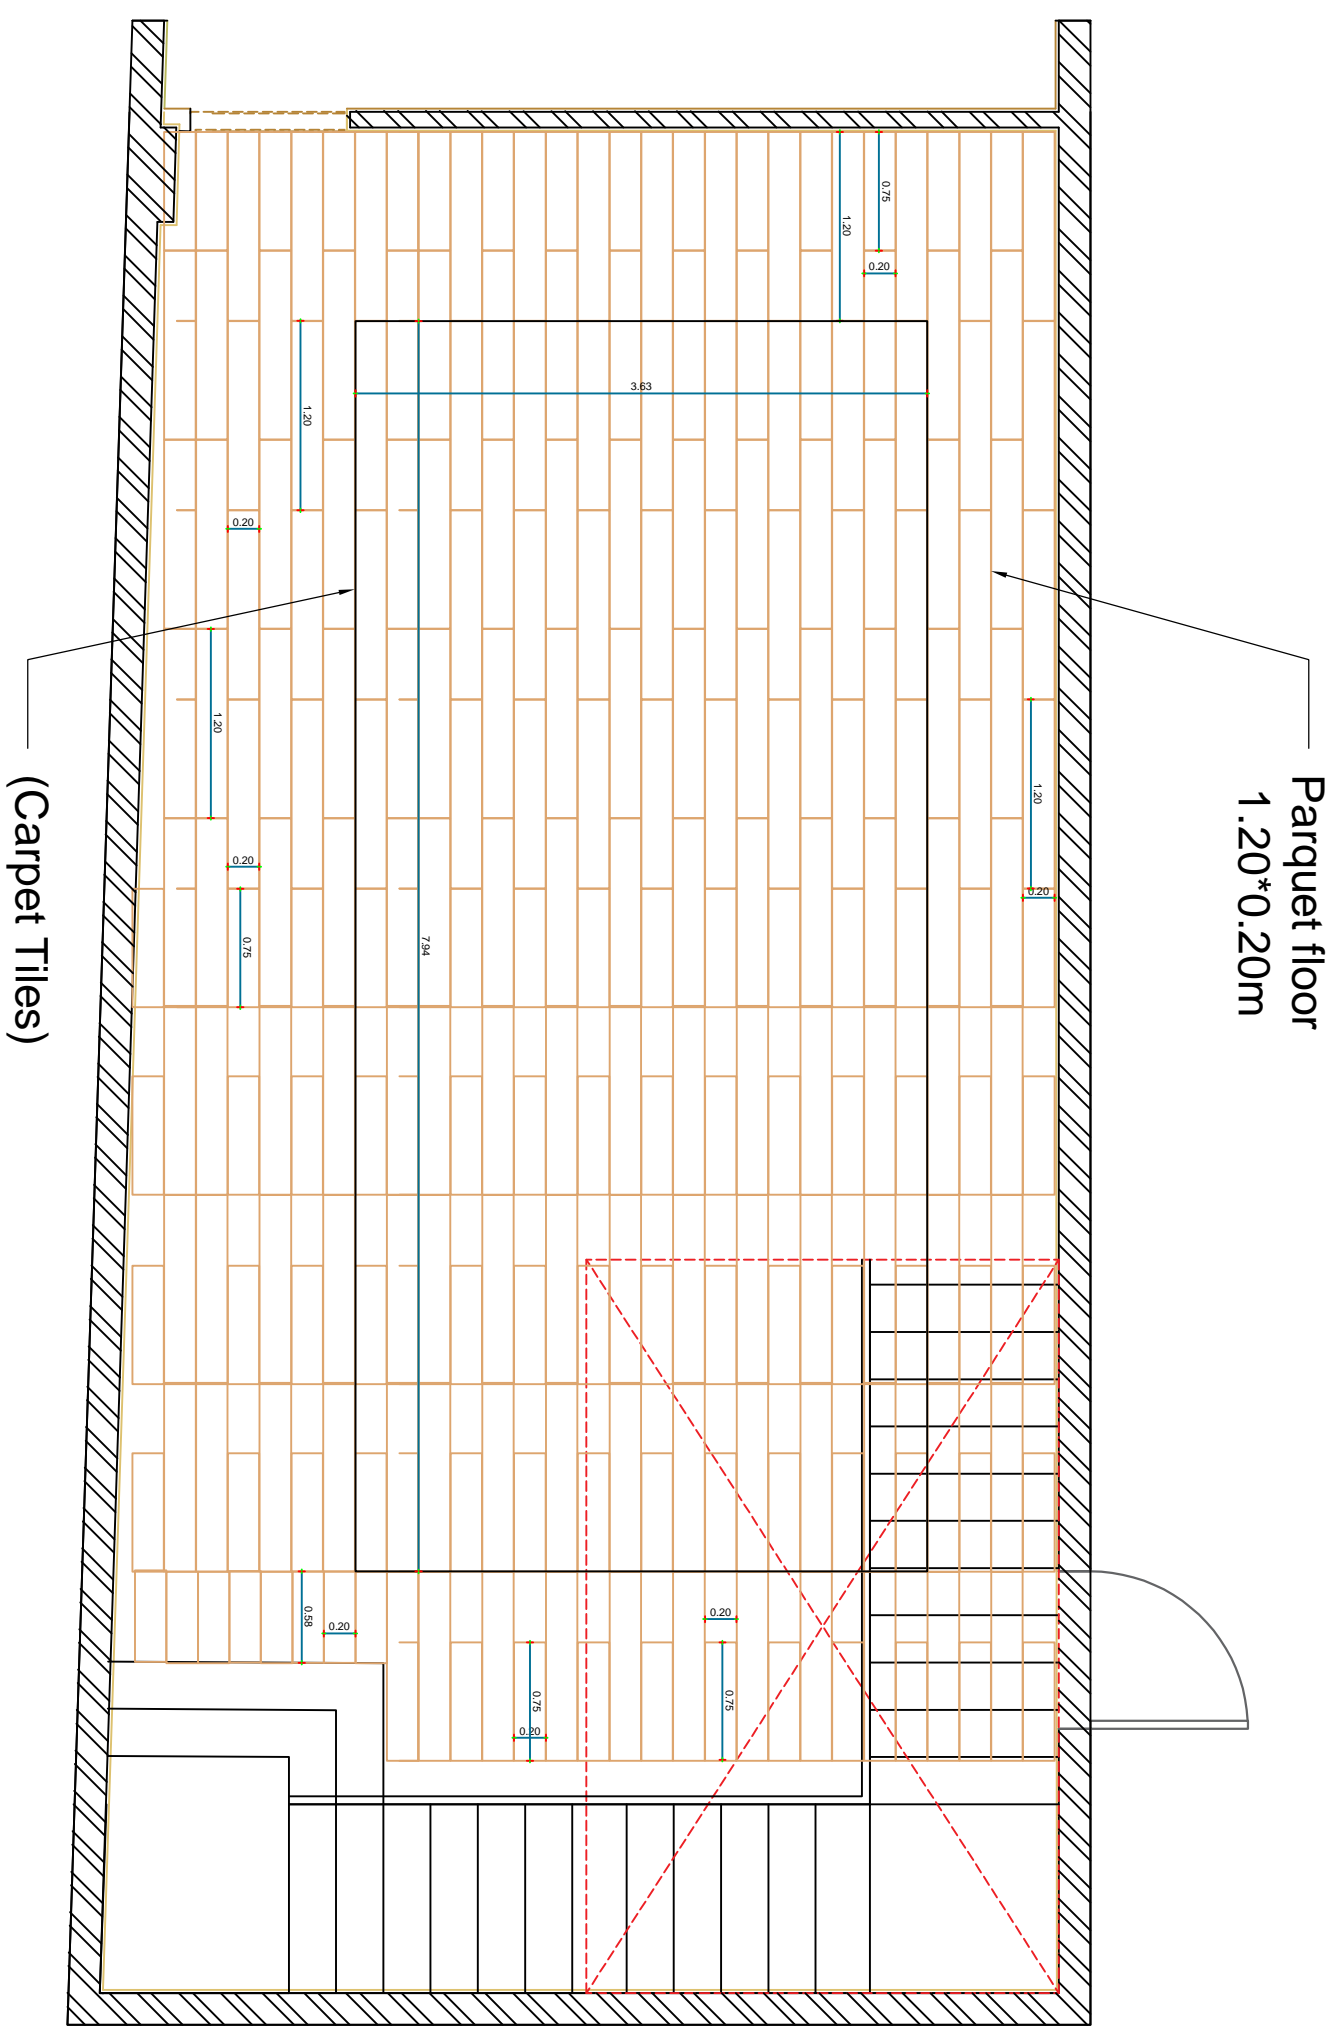


GROUND FLOOR  
**FLOORING PLAN**  
 SCALE 1:50

**Notes:**  
 This is a concept design details, shop drawings to be done by the contractors to meet the feel and look of the design perspectives, any discrepancy in the drawings the concept perspectives design should supersede and the contractor to highlight these before any execution to avoid any confusion and work execution miss matching the design concept.

Client :	
Project :	
Residential	
Space title : <b>Administrative offices</b>	
Drawing title :	
Design concept :	Checked by :
Date :	Drawing No : 00

- GENERAL NOTES:-**
1. ALL DIMENSIONS ARE IN METERS AND (UNLESS NOTED OTHERWISE)
  2. DO NOT SCALE FROM THE DRAWINGS
  3. ANY DISCREPANCIES TO BE NOTED TO ARCHITECT IMMEDIATELY
  4. ALL DIMENSIONS TO BE CHECKED ON SITE
  5. ALL DRAWINGS SHOULD BE READ IN CONJUNCTION WITH OTHER RELEVANT DISCIPLINES AND CONTRACT DOCUMENTS

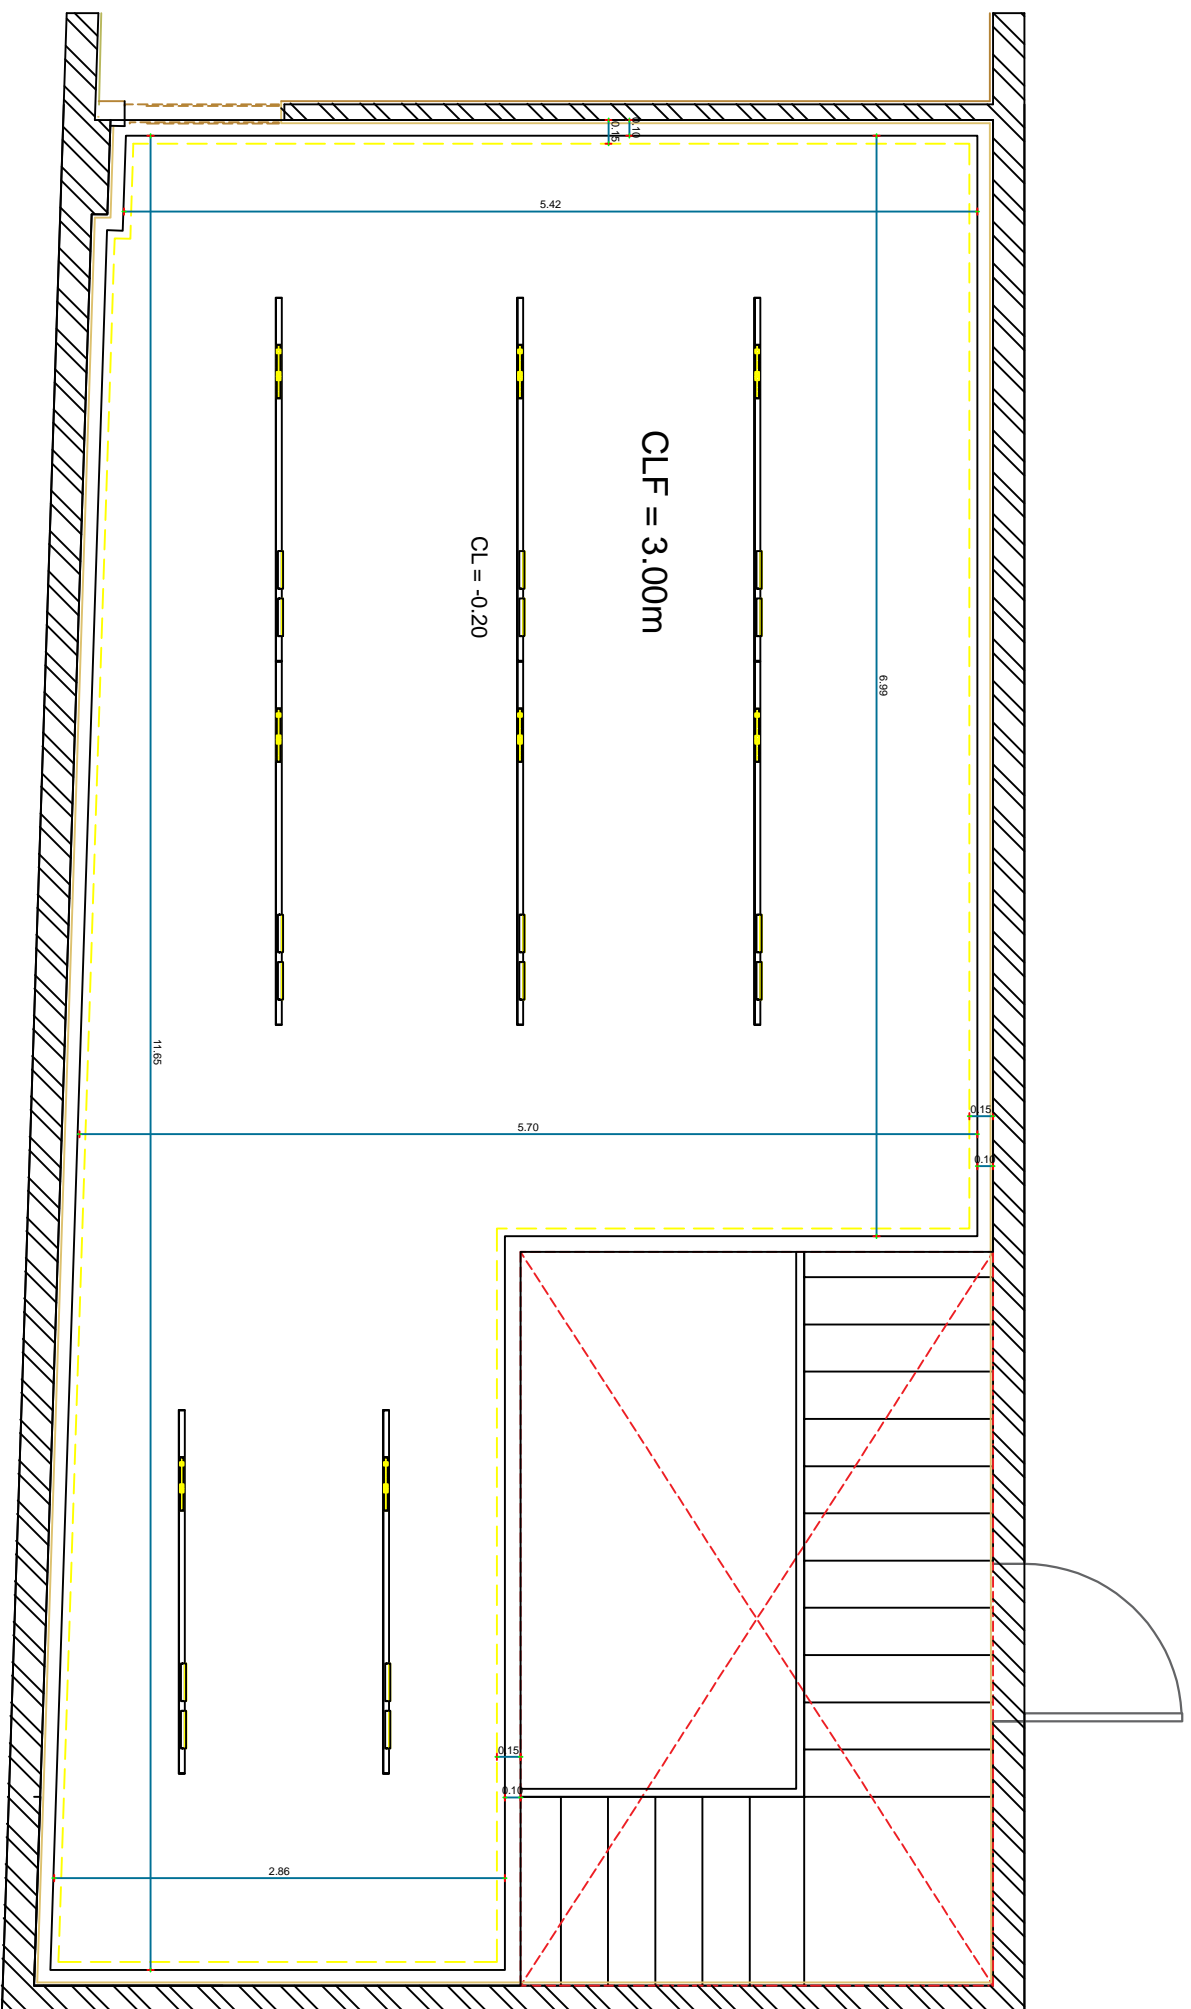


**5** GROUND FLOOR  
**CEILING PLAN**  
SCALE 1:50

**Notes:**  
This is a concept design details, shop drawings to be done by the contractors to meet the feel and look of the design perspectives, any discrepancy in the drawings the concept perspectives design should supersede and the contractor to highlight these before any execution to avoid any confusion and work execution miss matching the design concept.

Client :	
Project :	<b>Residential</b>
Space title :	<b>Administrative offices</b>
Drawing title:	
Design concept :	Checked by :
Date :	Drawing No : 00

- GENERAL NOTES:-**
1. ALL DIMENSIONS ARE IN METERS AND (UNLESS NOTED OTHERWISE)
  2. DO NOT SCALE FROM THE DRAWINGS
  3. ANY DISCREPANCIES TO BE NOTED TO ARCHITECT IMMEDIATELY
  4. ALL DIMENSIONS TO BE CHECKED ON SITE
  5. ALL DRAWINGS SHOULD BE READ IN CONJUNCTION WITH OTHER RELEVANT DISCIPLINES AND CONTRACT DOCUMENTS

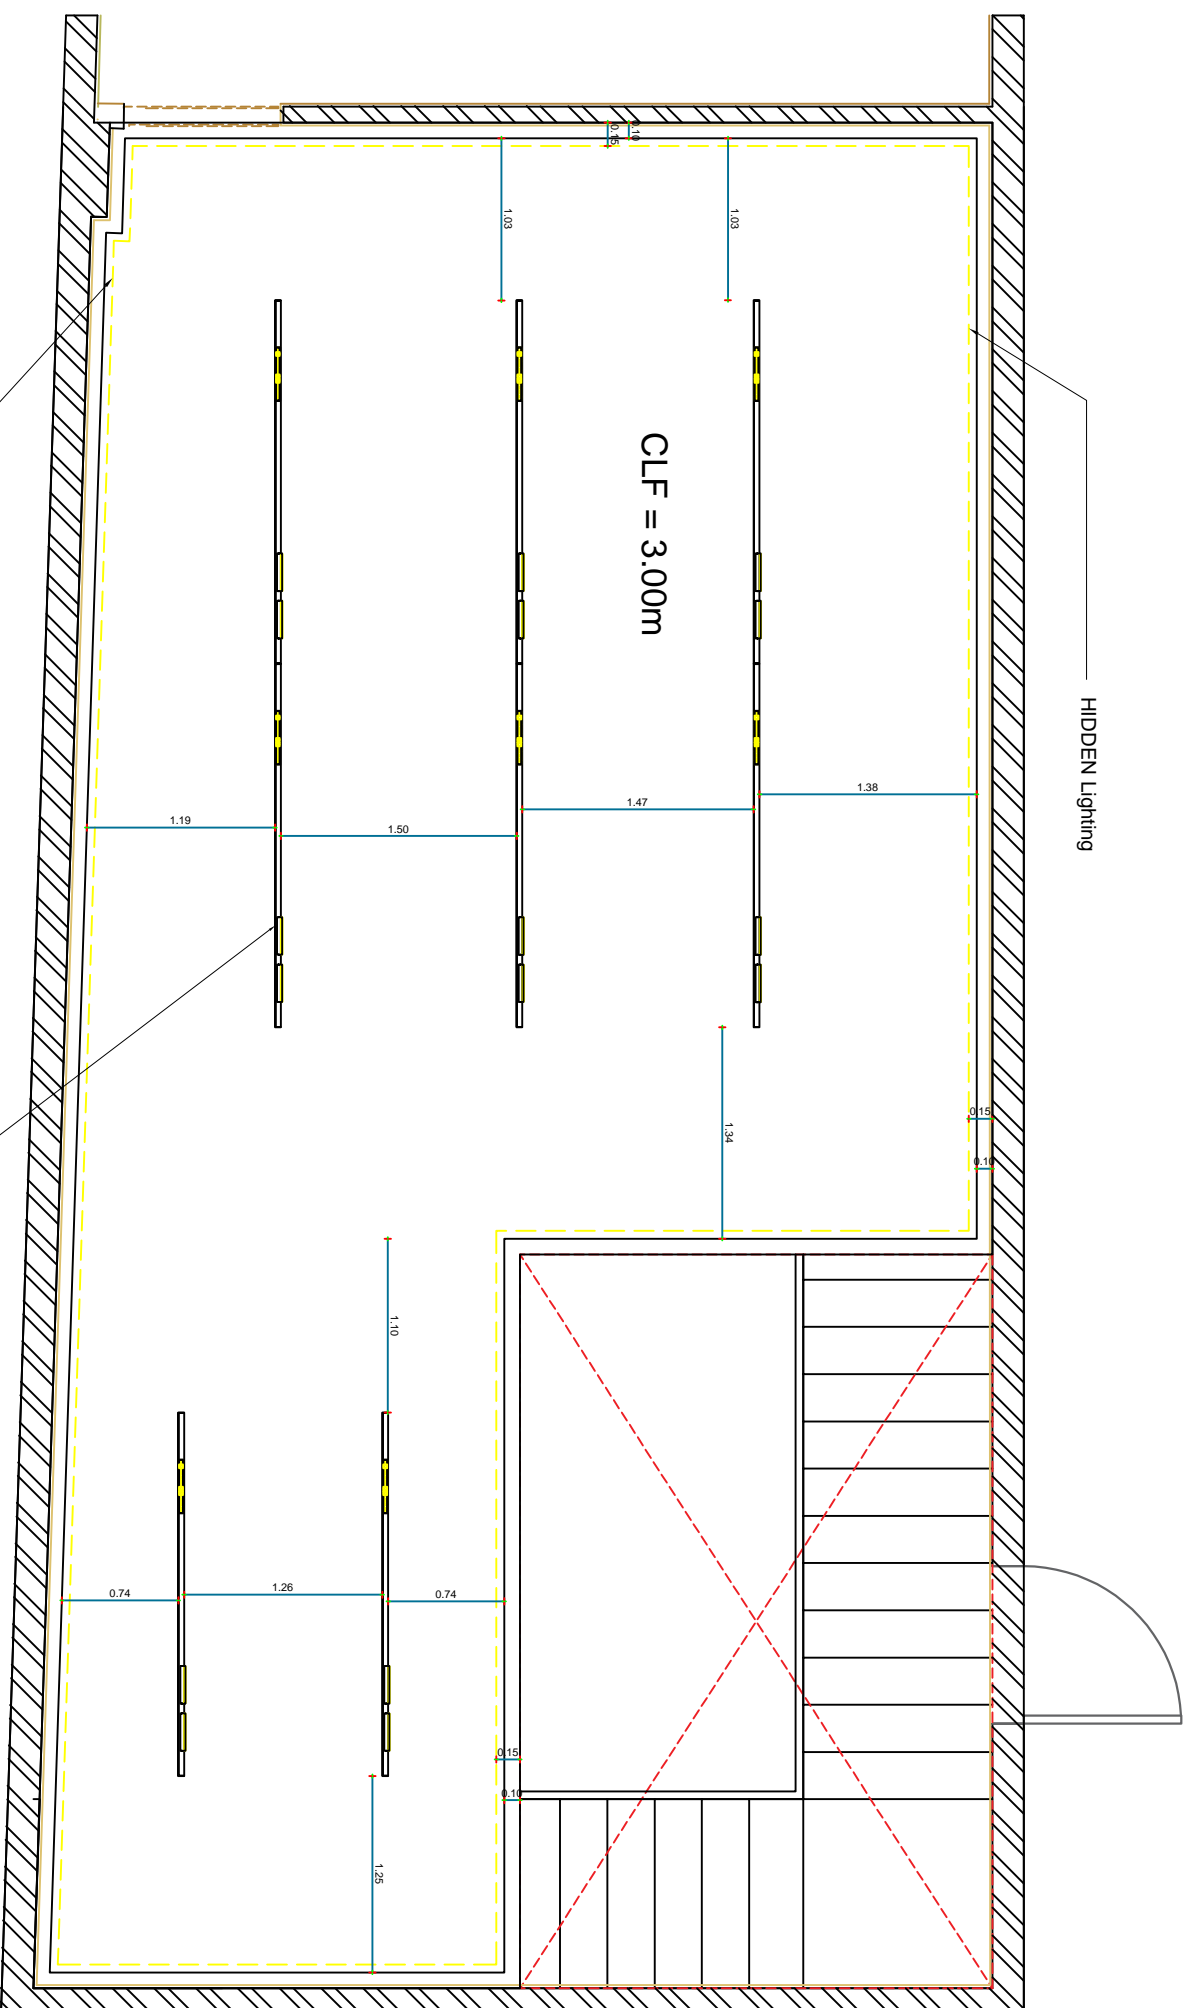


GROUND FLOOR  
**6 LIGHTING PLAN**  
 SCALE 1:50

**Notes:**  
 This is a concept design details, shop drawings to be done by the contractors to meet the feel and look of the design perspectives, any discrepancy in the drawings the concept perspectives design should supersede and the contractor to highlight these before any execution to avoid any confusion and work execution miss matching the design concept.

Client :	
Project :	Residential
Space title :	Administrative offices
Drawing title:	
Design concept :	Checked by :
Date :	Drawing No : 00

- GENERAL NOTES:-**
1. ALL DIMENSIONS ARE IN METERS AND (UNLESS NOTED OTHERWISE)
  2. DO NOT SCALE FROM THE DRAWINGS
  3. ANY DISCREPANCIES TO BE NOTED TO ARCHITECT IMMEDIATELY
  4. ALL DIMENSIONS TO BE CHECKED ON SITE
  5. ALL DRAWINGS SHOULD BE READ IN CONJUNCTION WITH OTHER RELEVANT DISCIPLINES AND CONTRACT DOCUMENTS

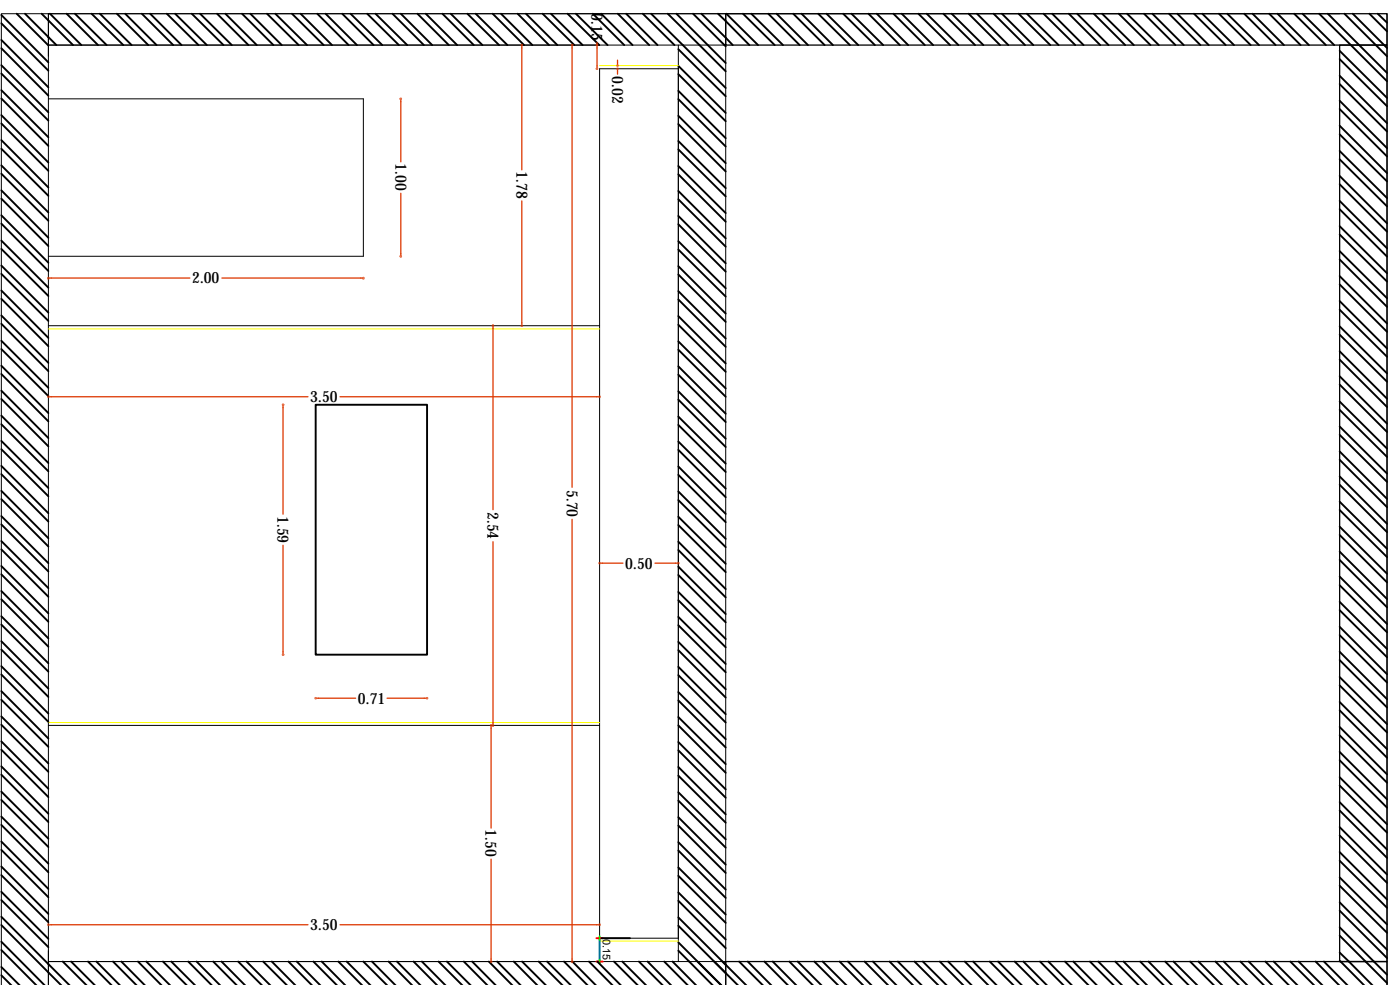


**GROUND FLOOR**  
**7 ELEVATION A (1)**  
 SCALE 1:50

**Notes:**  
 This is a concept design details, shop drawings to be done by the contractors to meet the feel and look of the design perspectives, any discrepancy in the drawings the concept perspectives design should supersede and the contractor to highlight these before any execution to avoid any confusion and work execution miss matching the design concept.

Client :	
Project : <b>Residential</b>	
Space title : <b>Administrative offices</b>	
Drawing title :	
Design concept :	Checked by :
Date :	Drawing No : 00

- GENERAL NOTES:-**
1. ALL DIMENSIONS ARE IN METERS AND (UNLESS NOTED OTHERWISE)
  2. DO NOT SCALE FROM THE DRAWINGS
  3. ANY DISCREPANCIES TO BE NOTED TO ARCHITECT IMMEDIATELY
  4. ALL DIMENSIONS TO BE CHECKED ON SITE
  5. ALL DRAWINGS SHOULD BE READ IN CONJUNCTION WITH OTHER RELEVANT DISCIPLINES AND CONTRACT DOCUMENTS

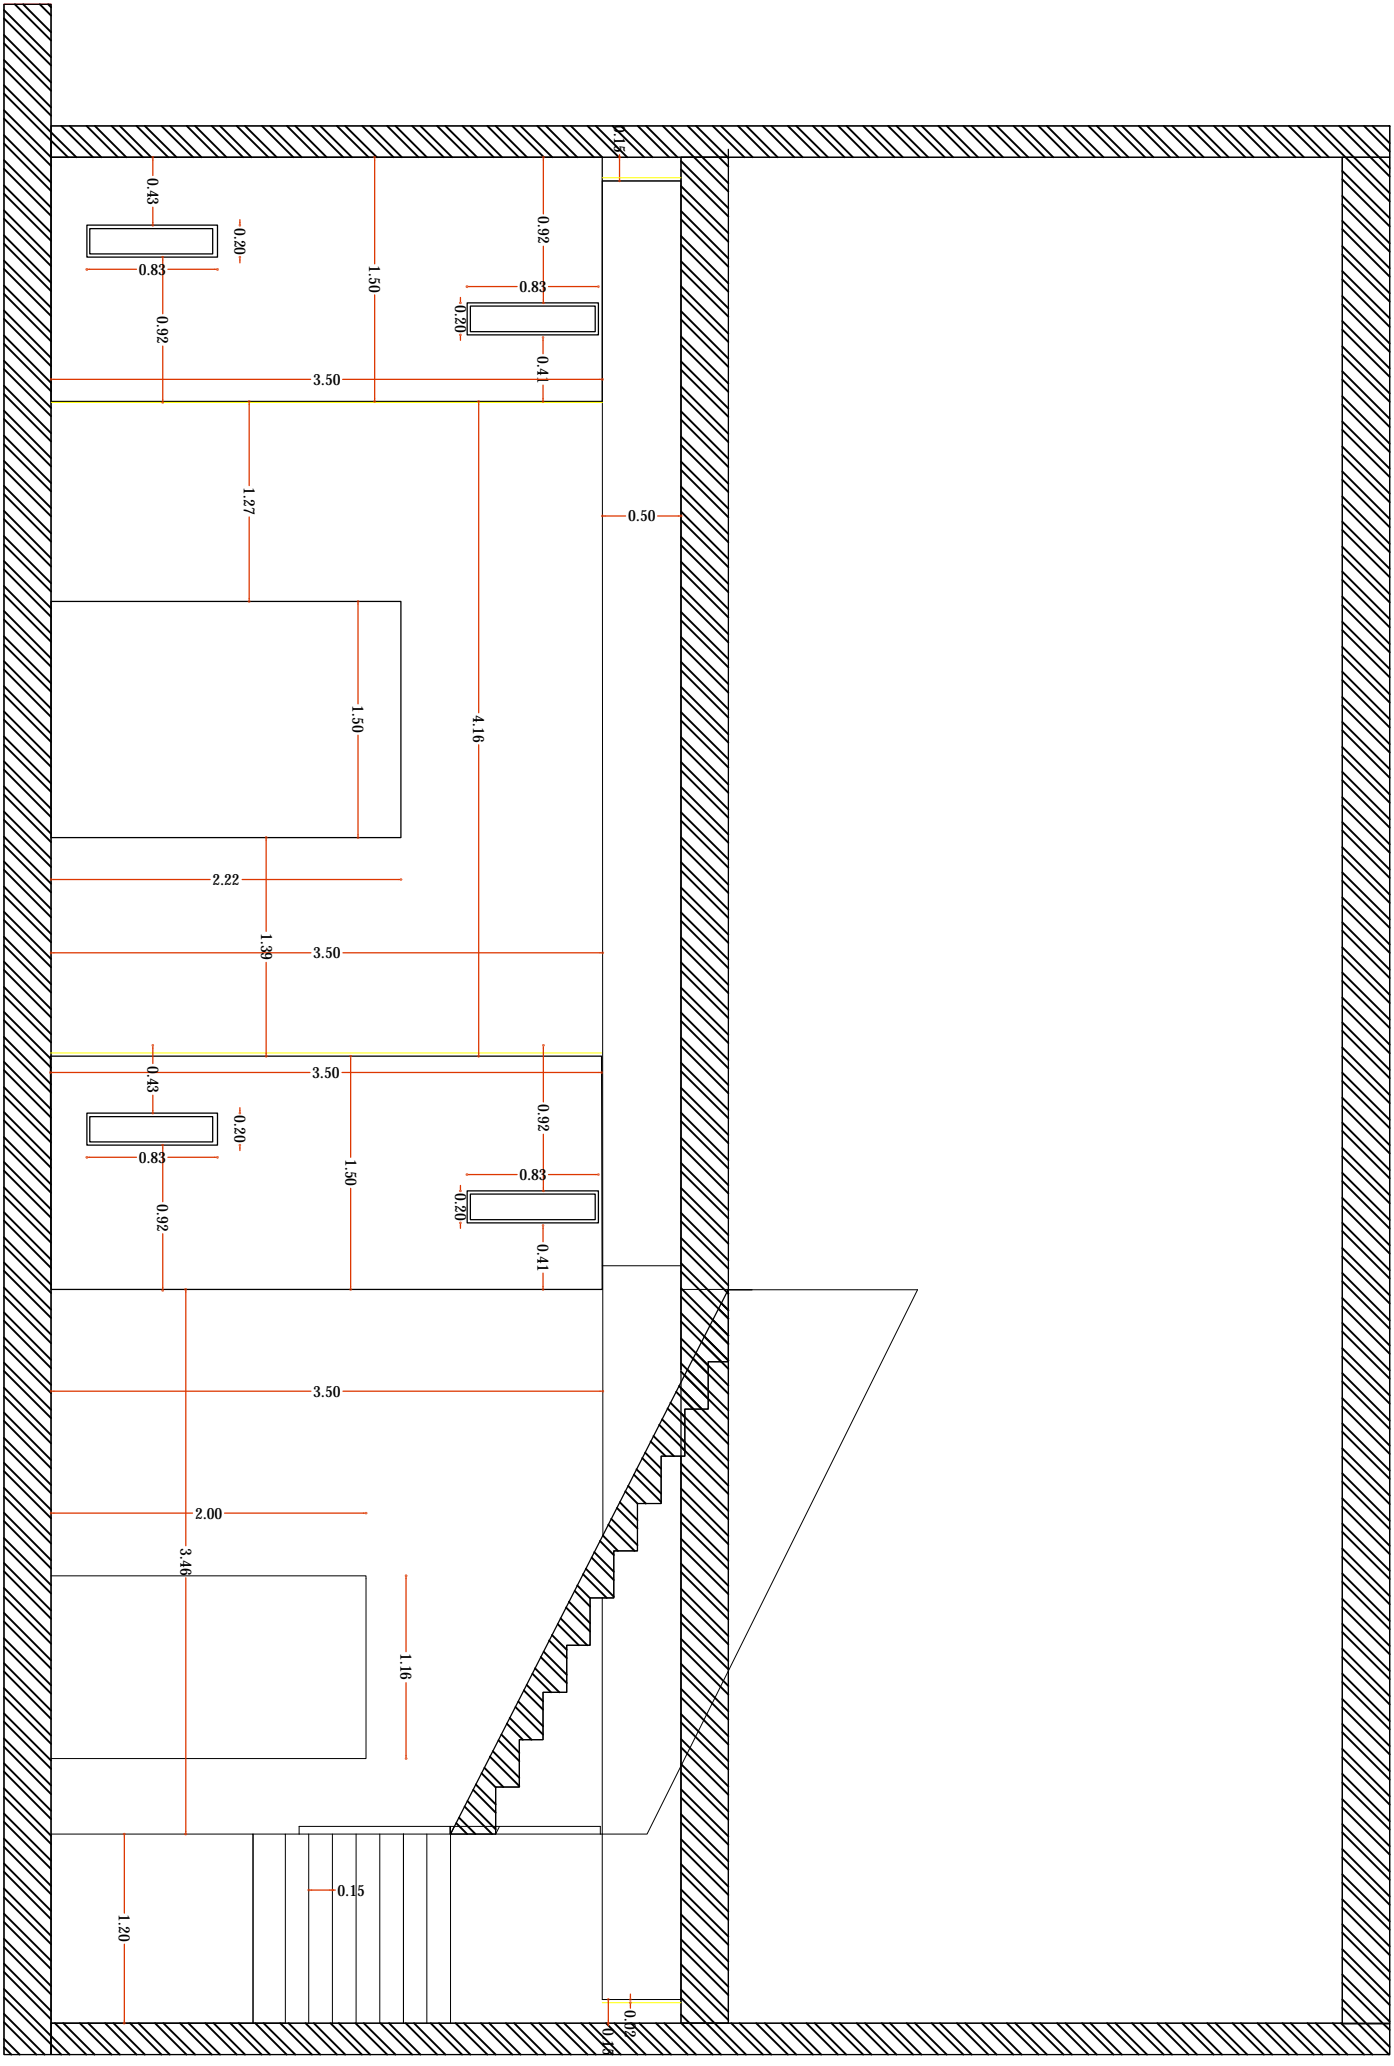


GROUND FLOOR  
**8 ELEVATION B (2)**  
 SCALE 1:50

**Notes:**  
 This is a concept design details, shop drawings to be done by the contractors to meet the feel and look of the design perspectives, any discrepancy in the drawings the concept perspectives design should supersede and the contractor to highlight these before any execution to avoid any confusion and work execution miss matching the design concept.

Client :	
Project :	<b>Residential</b>
Space title :	<b>Administrative offices</b>
Drawing title :	
Design concept :	Checked by :
Date :	Drawing No : 00

**GENERAL NOTES:-**

1. ALL DIMENSIONS ARE IN METERS AND (UNLESS NOTED OTHERWISE)
2. DO NOT SCALE FROM THE DRAWINGS
3. ANY DISCREPANCIES TO BE NOTED TO ARCHITECT IMMEDIATELY
4. ALL DIMENSIONS TO BE CHECKED ON SITE
5. ALL DRAWINGS SHOULD BE READ IN CONJUNCTION WITH OTHER RELEVANT DISCIPLINES AND CONTRACT DOCUMENTS

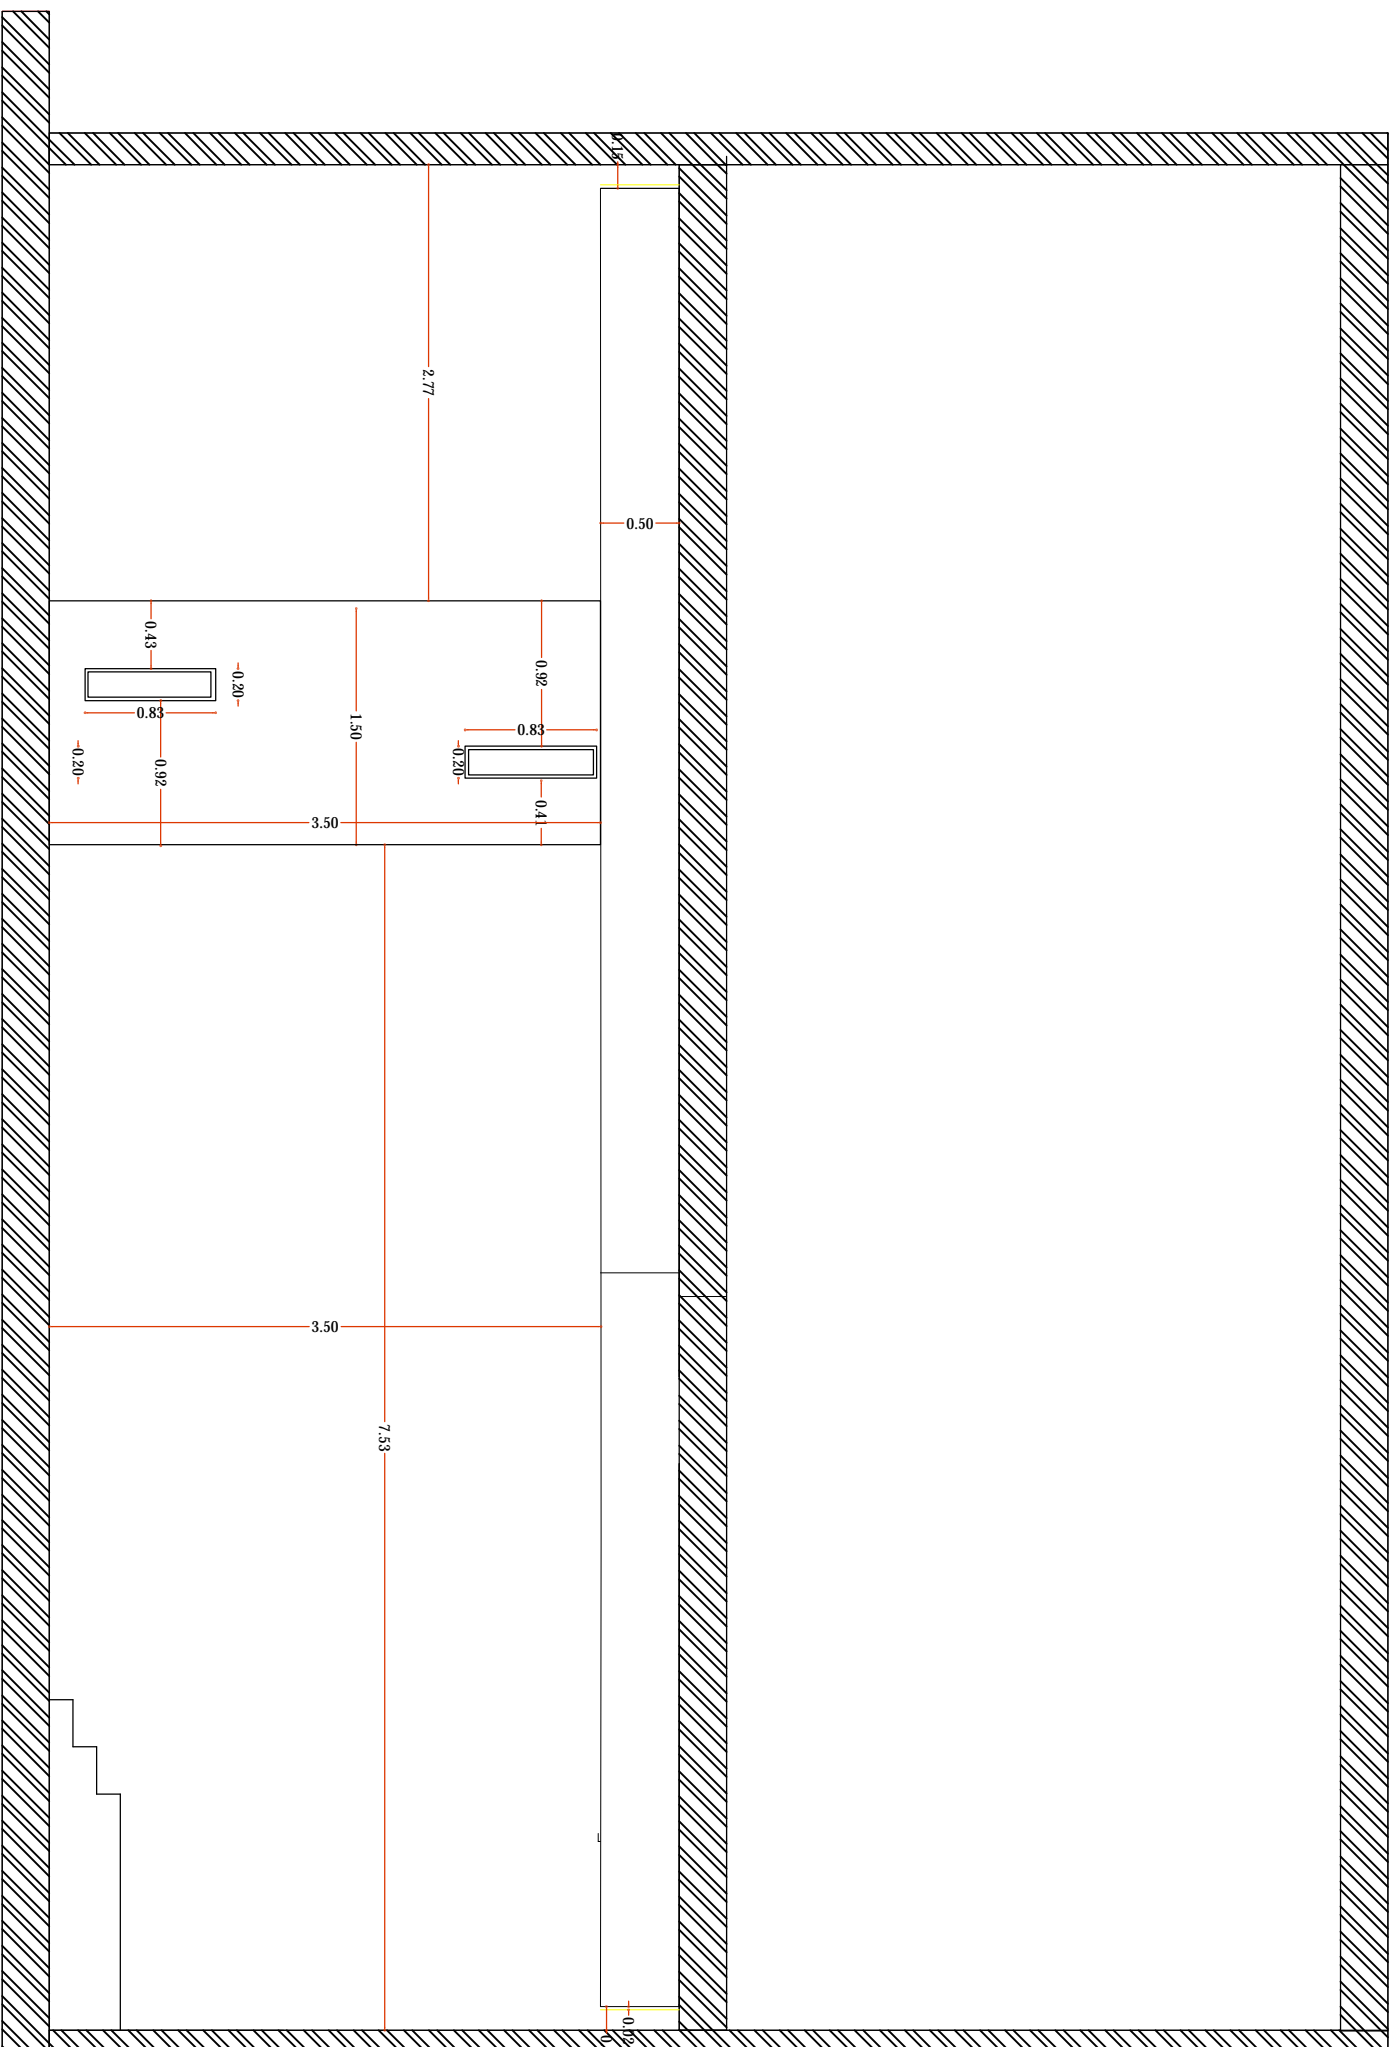

**9** GROUND FLOOR  
**ELEVATION C (3)**  
SCALE 1:50

**Notes:**

This is a concept design details, shop drawings to be done by the contractors to meet the feel and look of the design perspectives, any discrepancy in the drawings the concept perspectives design should supersede and the contractor to highlight these before any execution to avoid any confusion and work execution miss matching the design concept.

Client :	
Project :	
Residential	
Space title : <b>Administrative offices</b>	
Drawing title :	
Design concept :	Checked by :
Date :	Drawing No : 00





JOTUN PAINT  
(warm Off-Whites)

JOTUN PAINT  
(warm Off-Whites)

Chipboard Sheets  
Natural Oak  
(السنديان الطبيعي الفاتح)

HIDDEN Lighting

Chipboard Sheets  
Natural Oak  
(السنديان الطبيعي الفاتح)

ANGING  
PLANTS

5CM DEEP  
WOODEN SHELVES

Parquet floor  
1.20\*0.20m

(Carpet Tiles)

Magnetic Track Lighting

(Green Wall)

ANGING  
PLANTS

**Notes:**

This is a concept design details, shop drawings to be done by the contractors to meet the feel and look of the design perspectives, any discrepancy in the drawings the concept perspectives design should supersede and the contractor to highlight these before any execution to avoid any confusion and work execution miss matching the design concept.

Client :	
Project :	
Residential	
Space title :	
Administrative offices	
Drawing title:	
Design concept :	Checked by :
Date :	Drawing No : 00